

DEMONSTRATION & MONITORING PROJECT

COLD CLIMATE AIR SOURCE HEAT PUMP & SOLAR HOT WATER HEATER

BETHEL, ALASKA

DO NOT USE SCALE 11X17 DRAWINGS - SPEC'D DRAWINGS ARE 24X36

DRAWING INDEX

ARCHITECTURAL DRAWINGS

- A1 FLOOR PLAN
- A2 EXTERIOR ELEVATIONS
- A3 BUILDING SECTION
- A4 BUILDING TRANSVERSE – LONGITUDINAL
- A5 INTERIOR ELEVATIONS
- A6 WALL SECTION & ROOF PLAN & DETAILS
- A7 SCHEDULES, WALL & DOOR TYPES, & DETAILS
- A8 WALL TYPES & OTHER DETAILS
- A9 STRUCTURAL INSULATED PANELS (SIP)
- A10 SIP FLOOR PLAN
- A11 SIP DETAILS
- A12 SIP DETAILS

STRUCTURAL DRAWINGS

- S1 FLOOR FRAMING PLAN
- S2 ROOF FRAMING PLANS & DETAILS
- S3 POST AND PAD DETAILS
- S4 PILE DETAILS
- S5 STAIR DETAILS

MECHANICAL DRAWINGS

- M0 MECHANICAL SCHEDULES
- M1 HEAT PUMP & APPURTENACES
- M2 FIXTURES, DWV & WATER ISOMETRIC
- M3 FIXTURE CONNECTION DETAILS
- M4 SOLAR HW HEATER & WATER TANK


ELECTRICAL DRAWINGS

- E001 LEGEND, FIXTURE SCHEDULE, & DETAILS
- E101 LIGHTING PLAN
- E201 POWER & SIGNAL PLAN
- E301 DETAILS
- E401 ELECTRICAL SPECIFICATIONS
- E501 MONITORING DIAGRAM & ARCHITECTURE
- E601 MONITORING FLOOR PLAN & SOLAR HOT WATER





3D PLAN MODEL
1268 Sq ft Single Family
R50 Ceiling – R24 Walls – R50 Floor
Heating Design Temp: -22F = Heat Loss 18,533 BTU/H

MECHANICAL & MONITORING
DESIGNED & ENGINEERED BY:

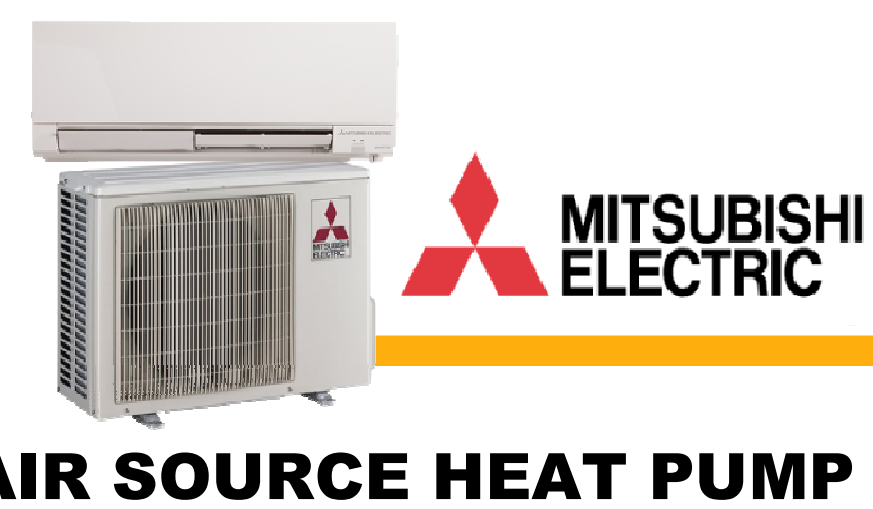

AIR SOURCE HEAT PUMP

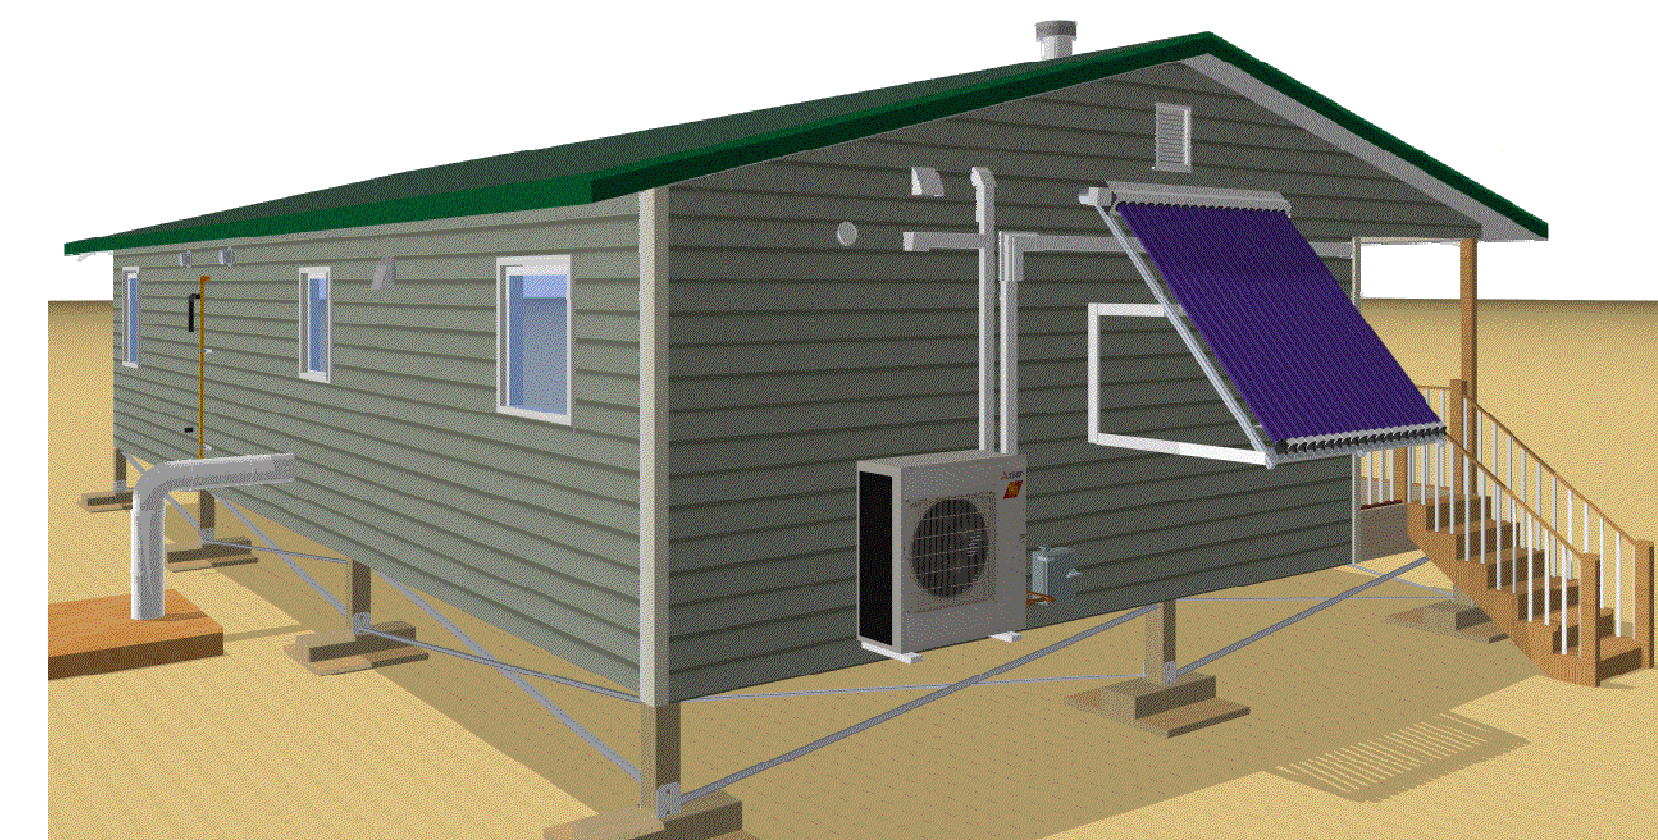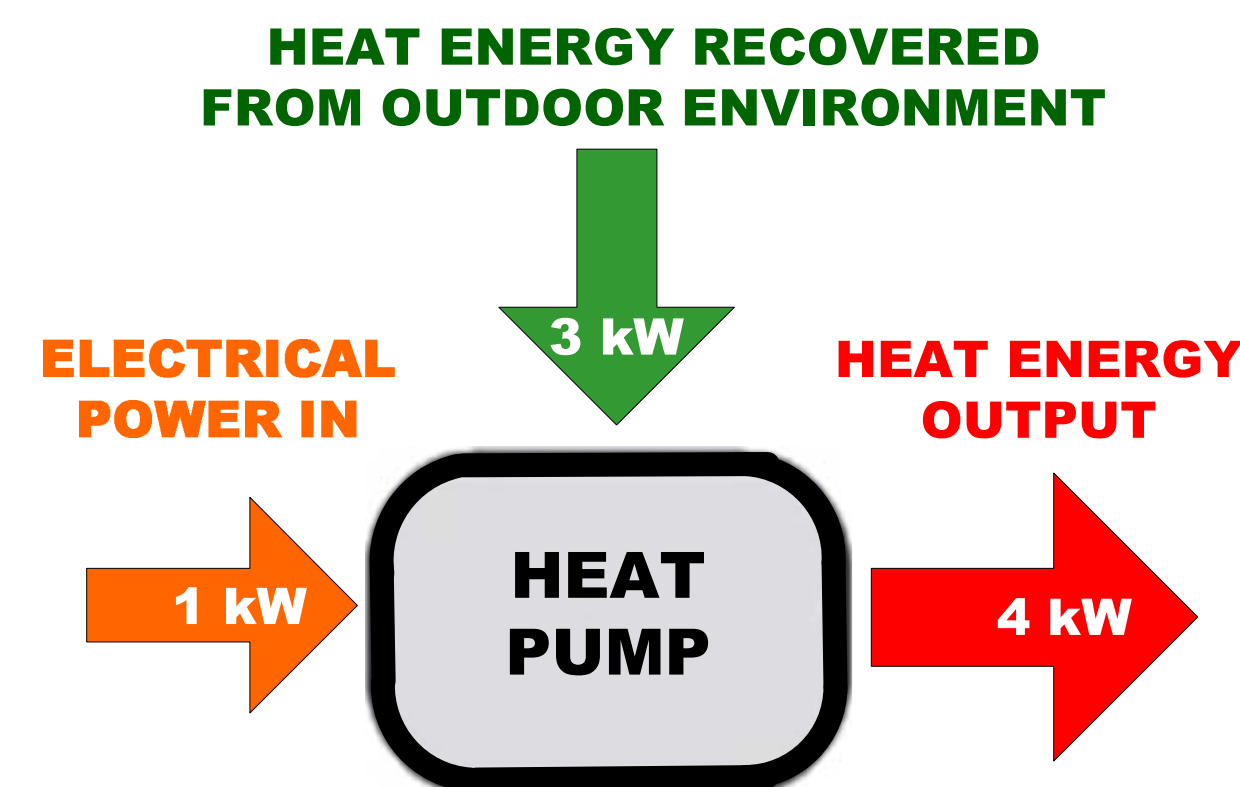

3D MODEL Design by jerry nicholson

MODEL HOME DRAWINGS USED BY PERMISSION FROM AVCP HOUSING AUTHORITY

REVISION 9/16/19

PROJECT DEMONSTRATION & MONITORING PROJECT FOR AIR SOURCE HEAT PUMPS
SYSTEM 1268 Sq ft Single Family
REVISION

TECHNOLOGICAL INNOVATION FOR RURAL ALASKA
DUCTLESS SPLIT SYSTEM
REVISION: None

OceanAir
HEATING & A/C
CONTRACTING LLC
HEAT PUMP SYSTEMS

Scale: n/a

Drawn by: jn


Date: 11/23/18

Job No.


Category

Sheet


C 0
COVER

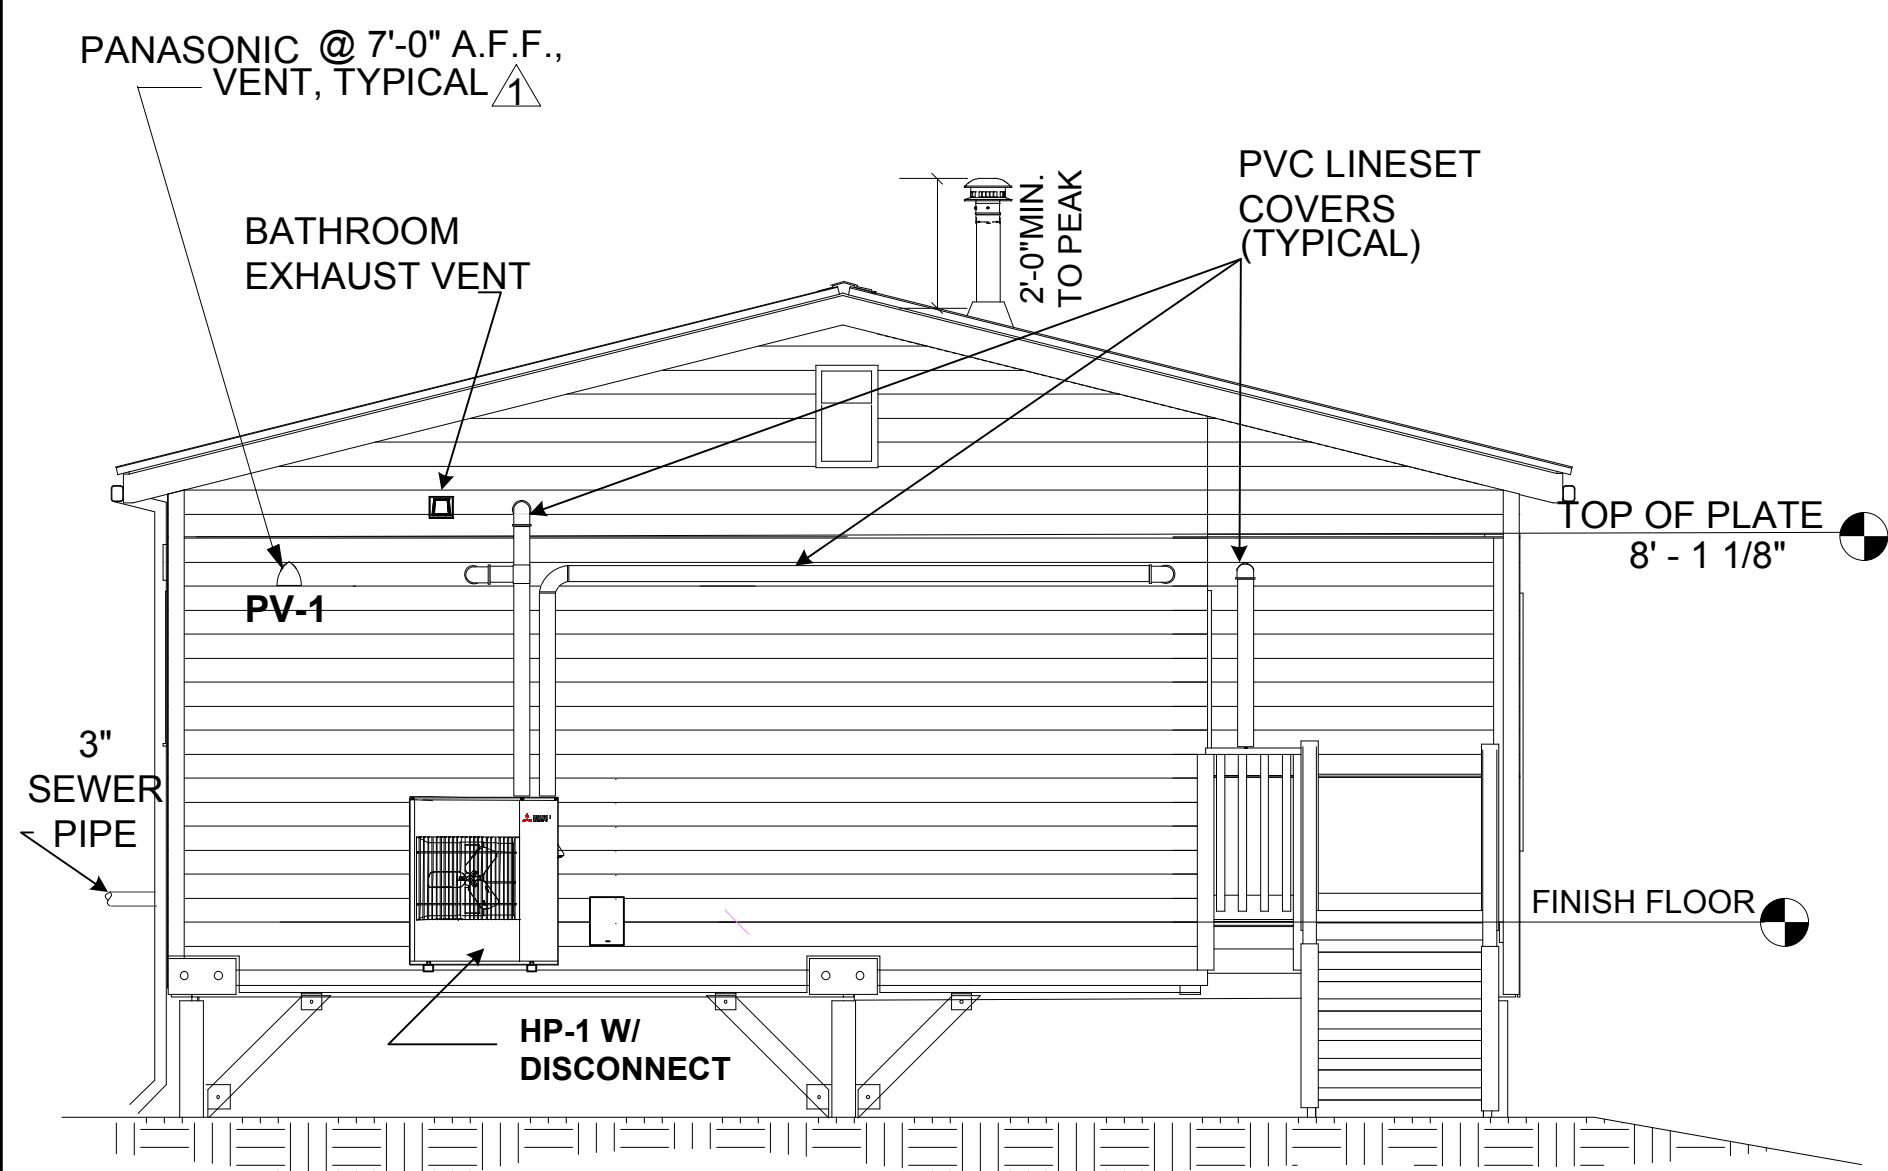



AA LEFT ELEVATION
M-1 Scale: 1/4" = 1'-0"

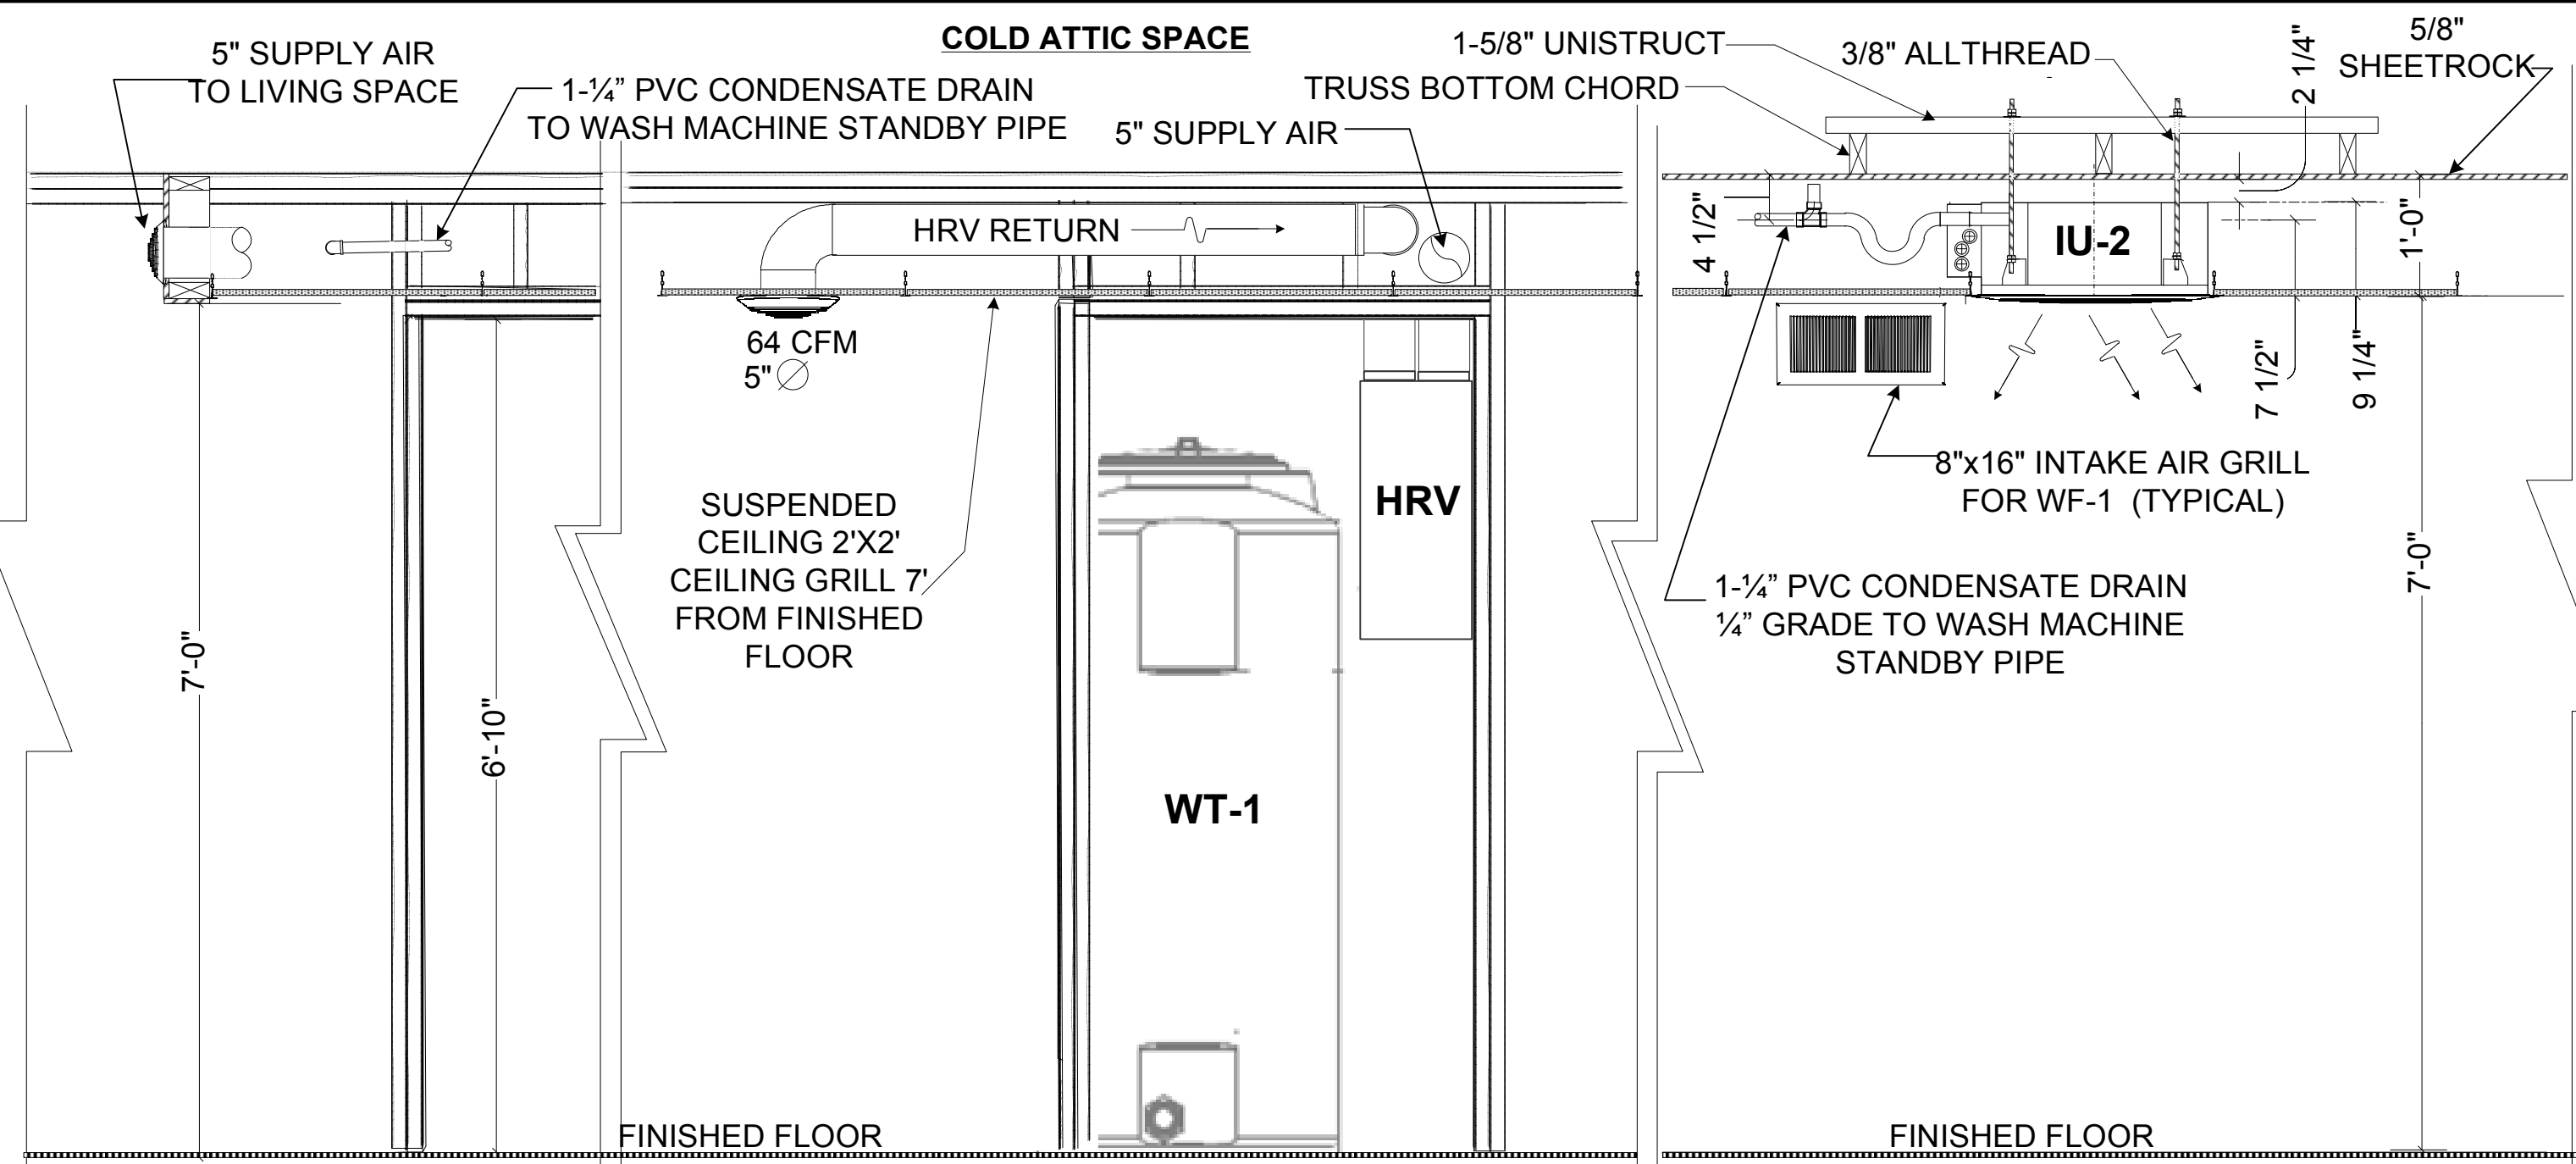


BB SECTION B-B HEAT PUMP CEILING UNIT - HRV DUCTING
M-1 SCALE: N/A

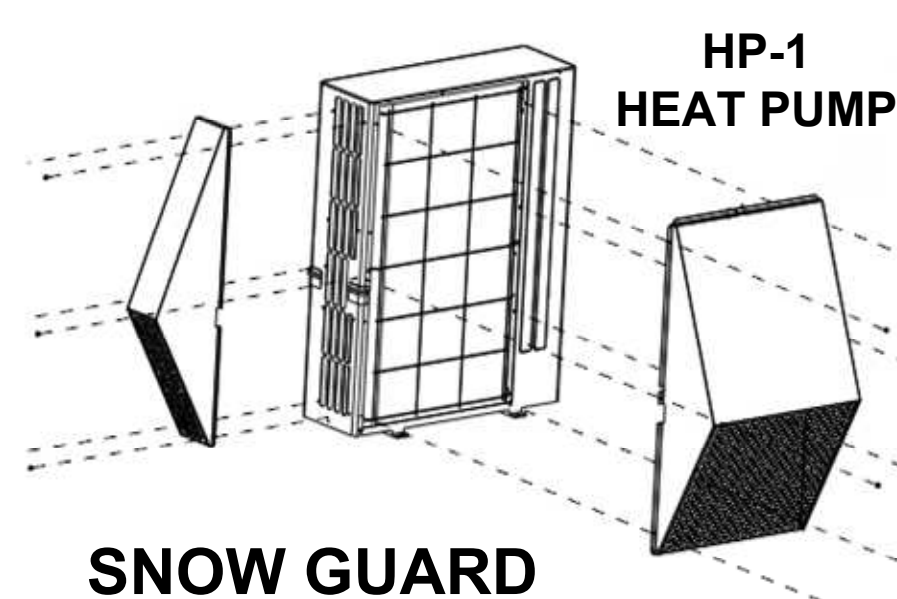


2 SG-1 DETAIL
M-1 NTS

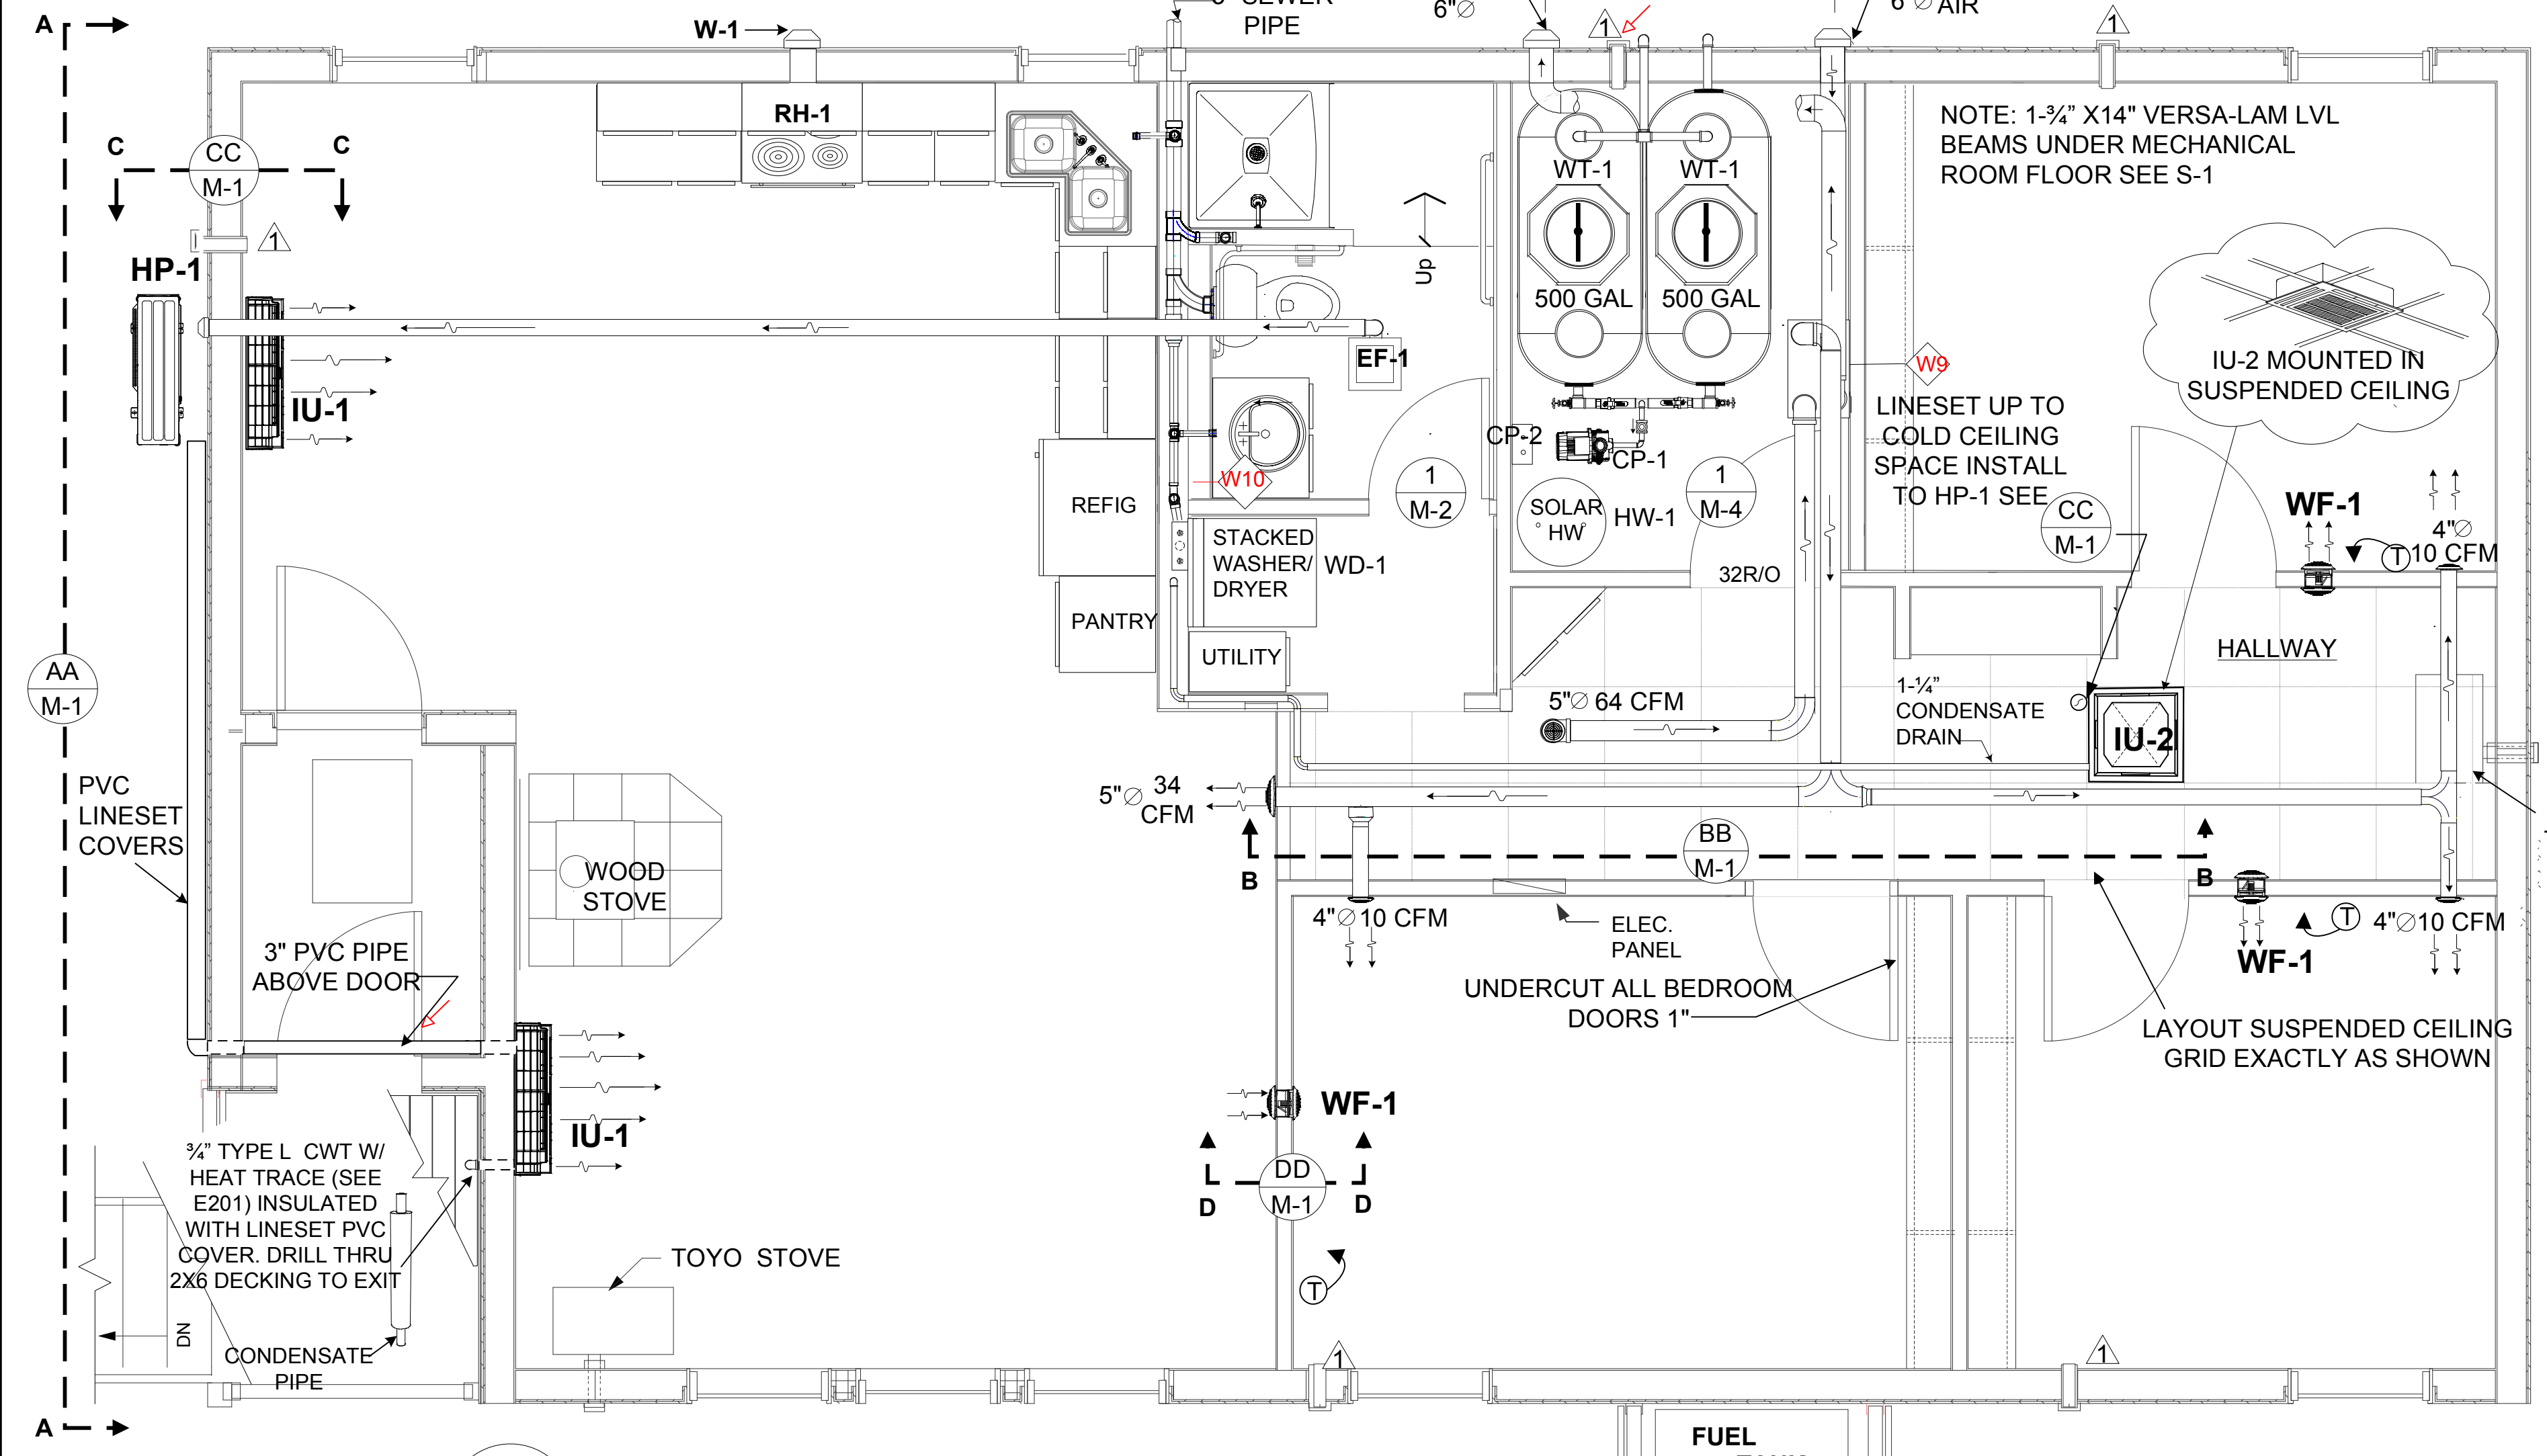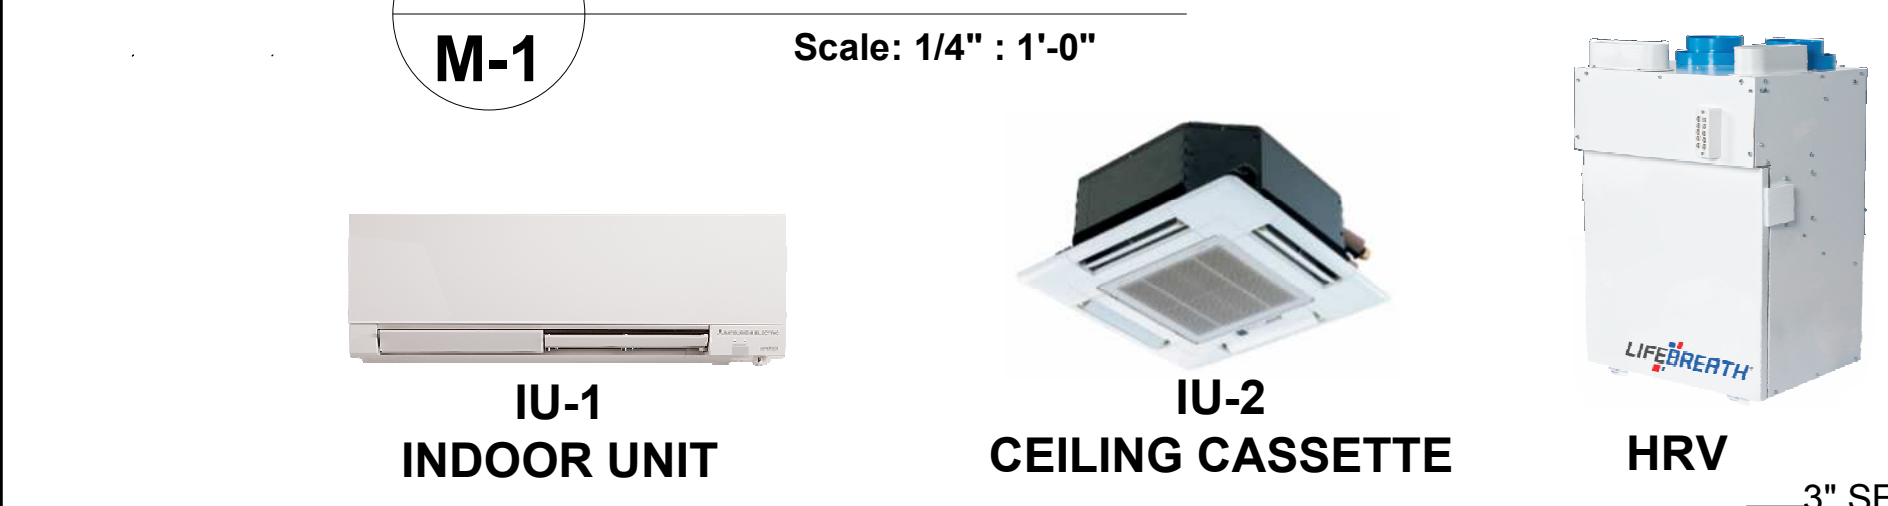


1 MECHANICAL/PLUMBING FLOOR PLAN
M-1 SCALE 3/8" = 1'-0"

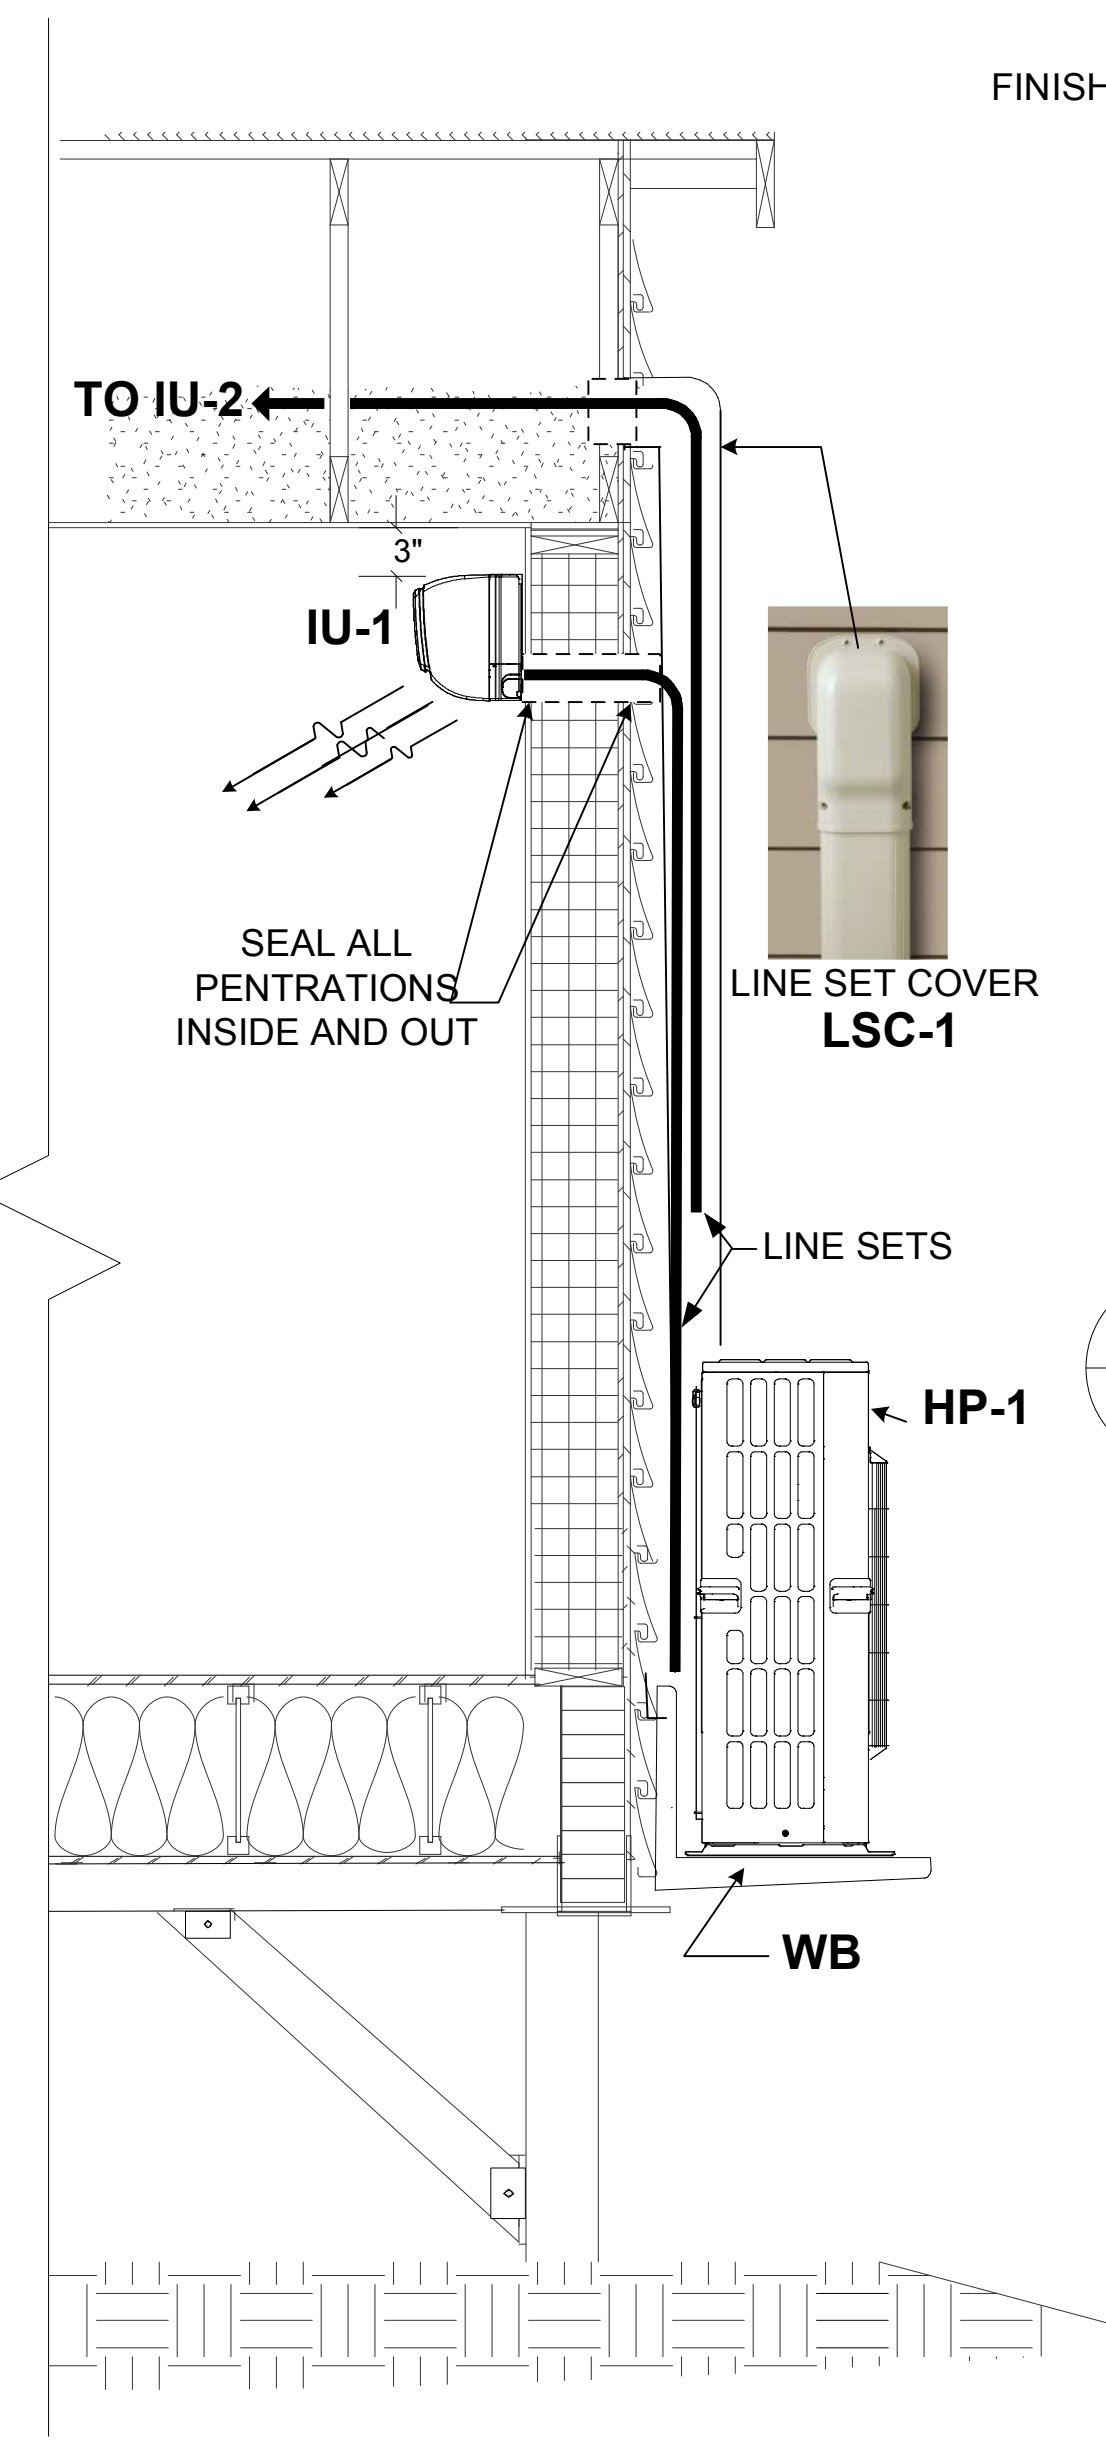

CC SECTION C-C HEAT PUMP
M-1 NTS

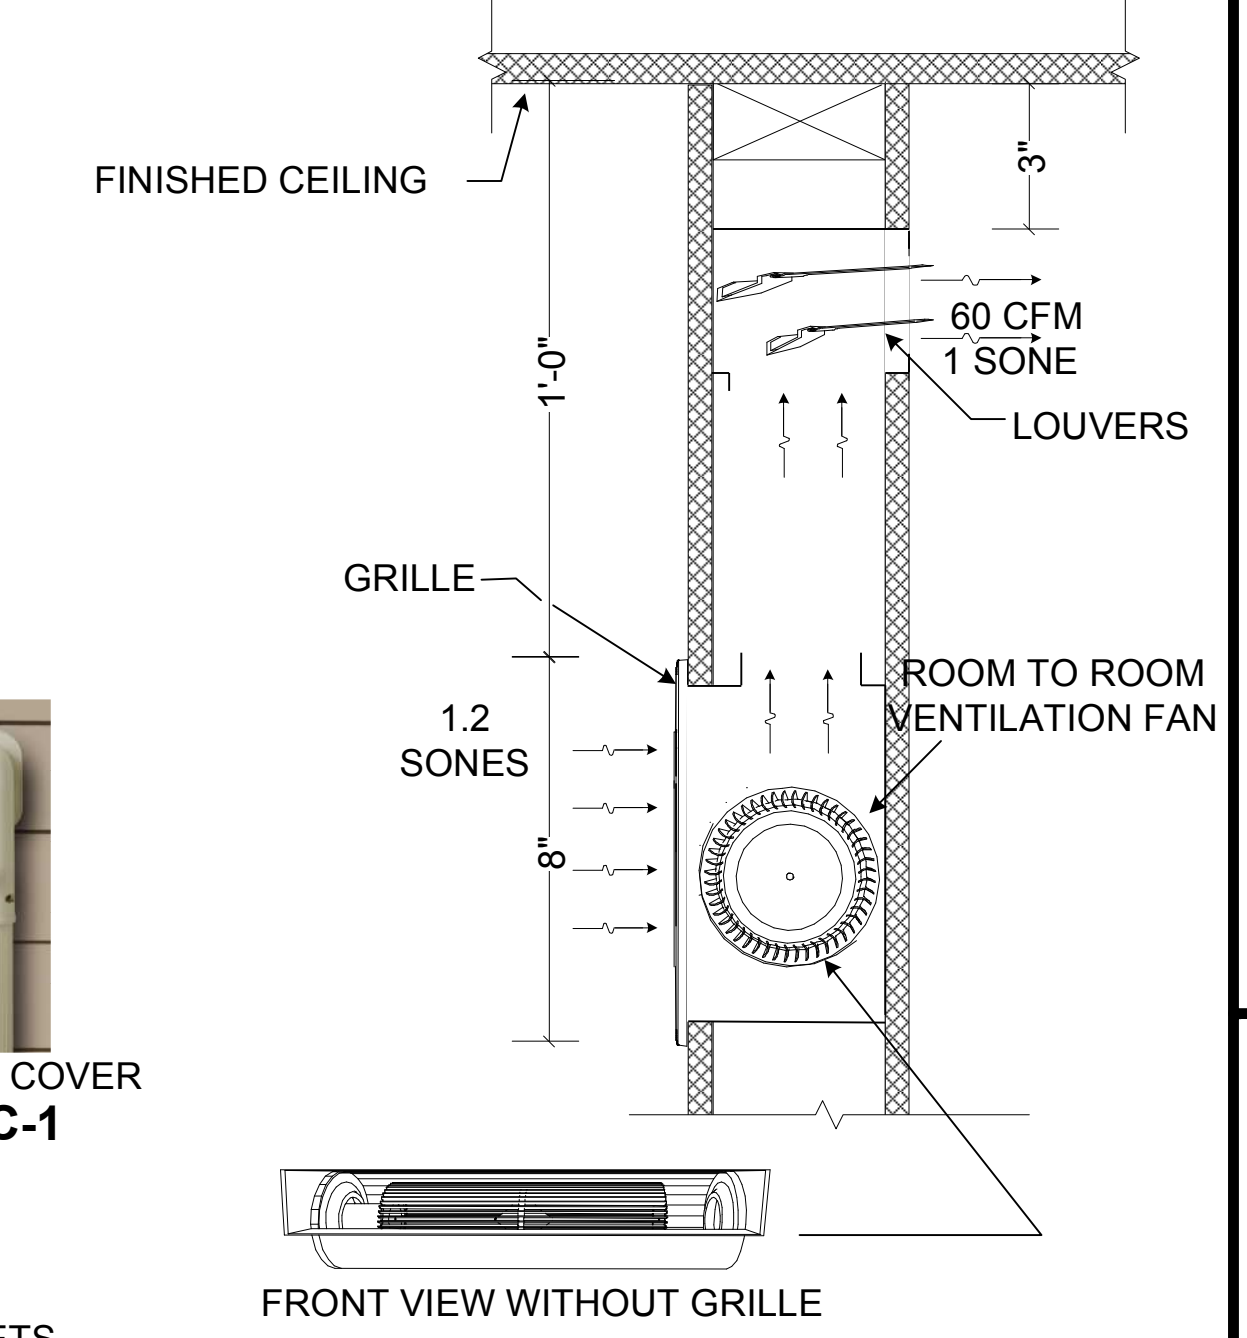

DD SECTION D-D FAN
M-1 NTS

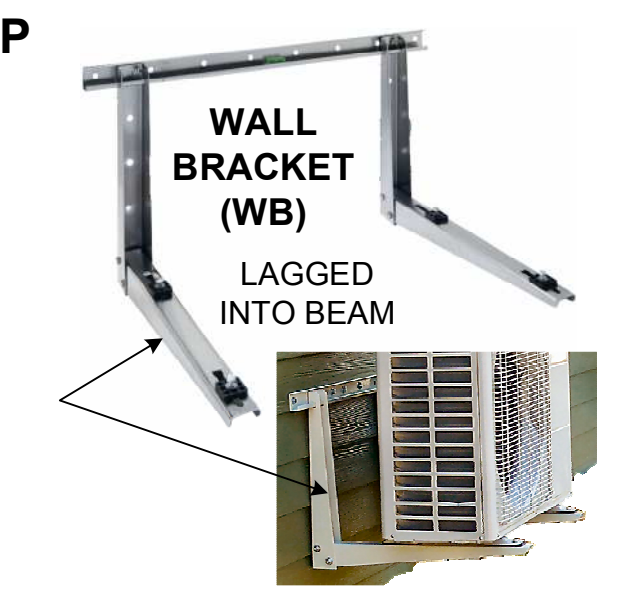


PROJECT DEMONSTRATION & MONITORING PROJECT FOR AIR SOURCE HEAT PUMPS
OWNER HEAT PUMP & APPURTENANCES
REVISION: None



Scale: per detail
Design/Drawing by: jn
Date: 6/5/19
Job No. Bethel Demo
Finished: 6/24/19
Category Sheet
M 1


MODEL HOME USED BY PERMISSION OF AVCP HOUSING AUTHORITY

DWV FITTINGS	
1	ABS 3x2 INCREASER
2	ABS 2 VENT TEE
3	ABS 2 VENT ELBOW
4	ABS 2X2X1-1/2 SAN TEE
5	ABS 1-1/2 TRAP ADAPTER TUBE
6	ABS 1-1/2 X 1-1/4 TRAP ADAPTER TUBE
7	ABS 3X3X2 COMBO
8	ABS 2 LONG SWEEP ELBOW
9	ABS 2 P-TRAP
10	ABS 3X3X3 COMBO
11	ABS 4X3 CLOSET FLANGE HUB
12	ABS 2 SAN TEE
13	PVC 2X2X1-1/4 TEE
14	PVC 2 ELBOW
15	PVC 2X2X1/2 TEE W/ HOSE BARB
16	ABS 2X2X2 COMBO

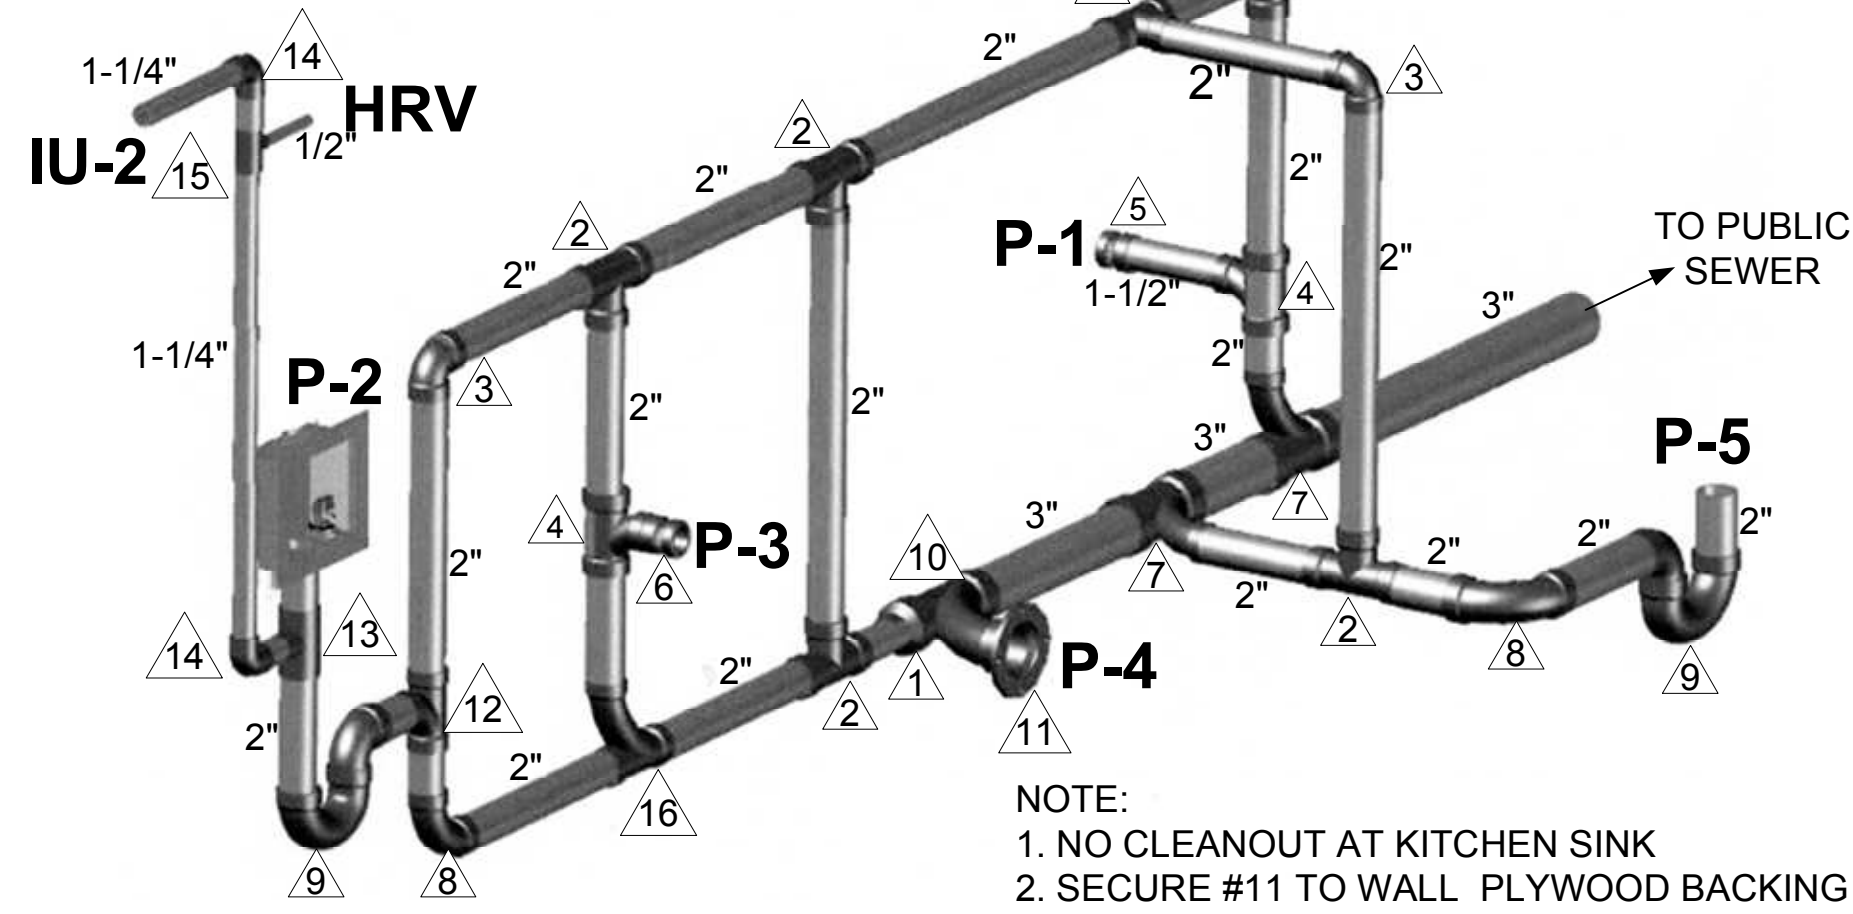


2 ABS DWV ISOMETRIC
PER UNIFORM PLUMBING CODE 2012 NTS


NOTE:
1. NO CLEANOUT AT KITCHEN SINK
2. SECURE #11 TO WALL PLYWOOD BACKING

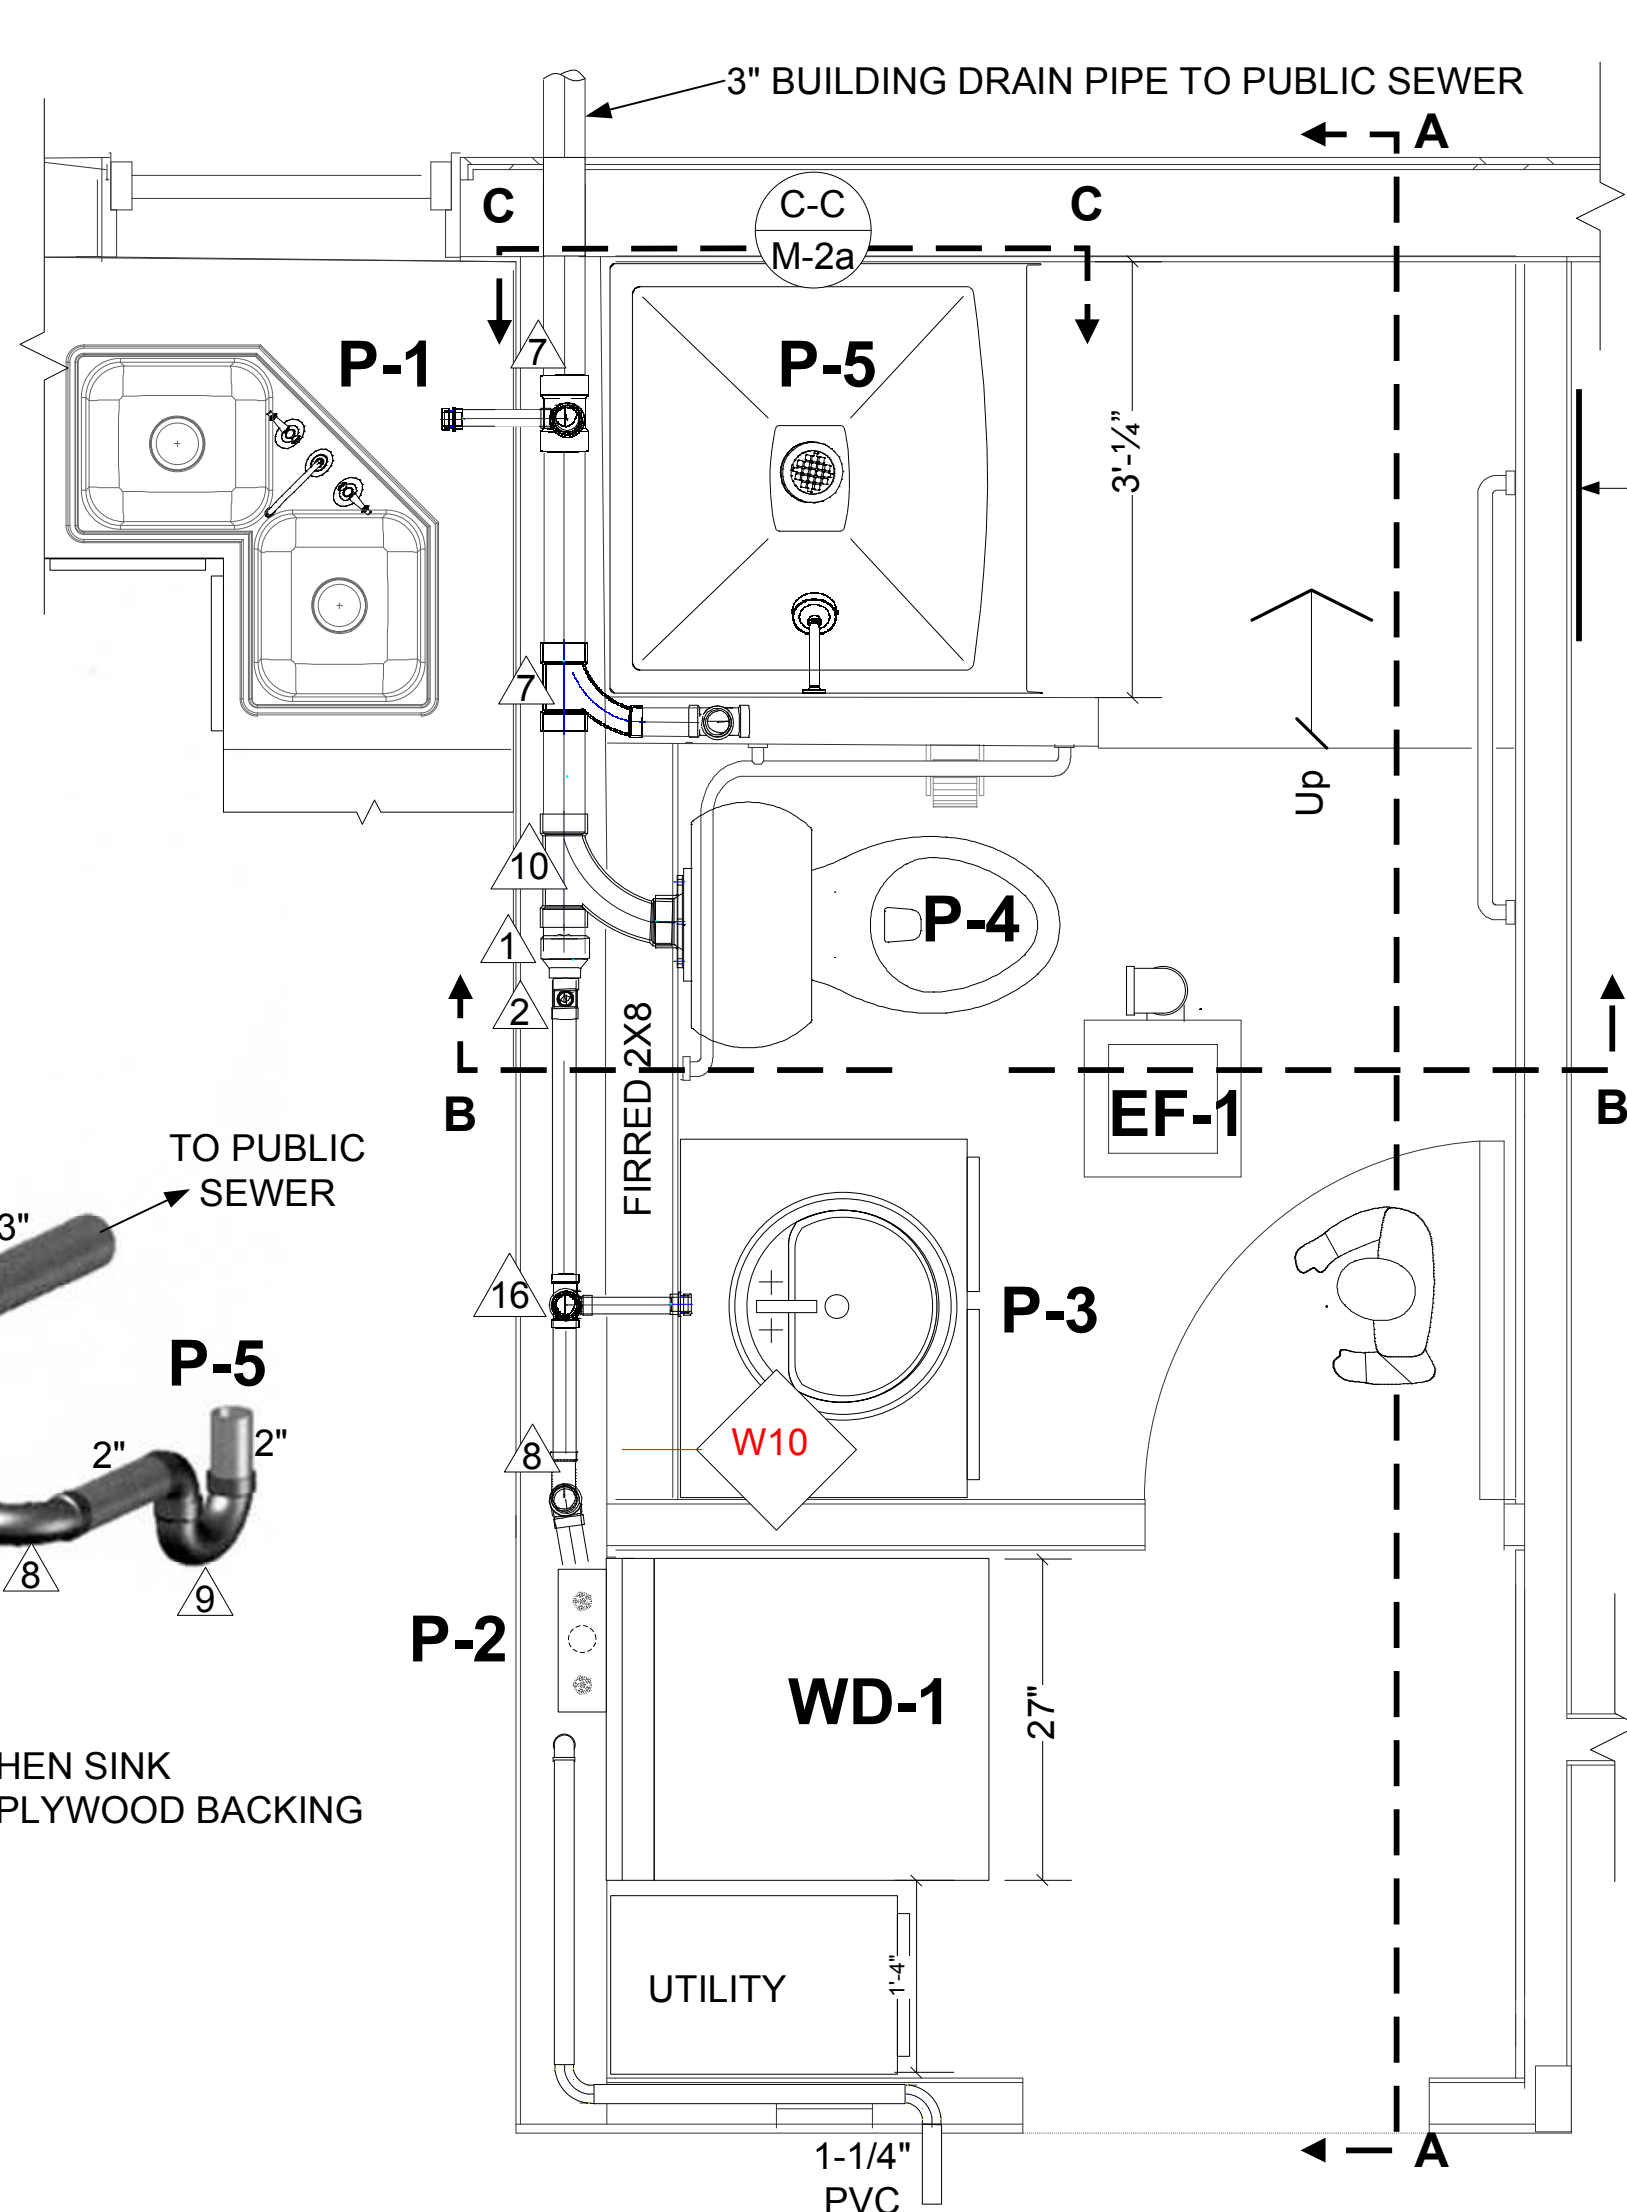


1 BATHROOM FIXTURE FLOOR PLAN
Scale: 3/4" = 1'-0"

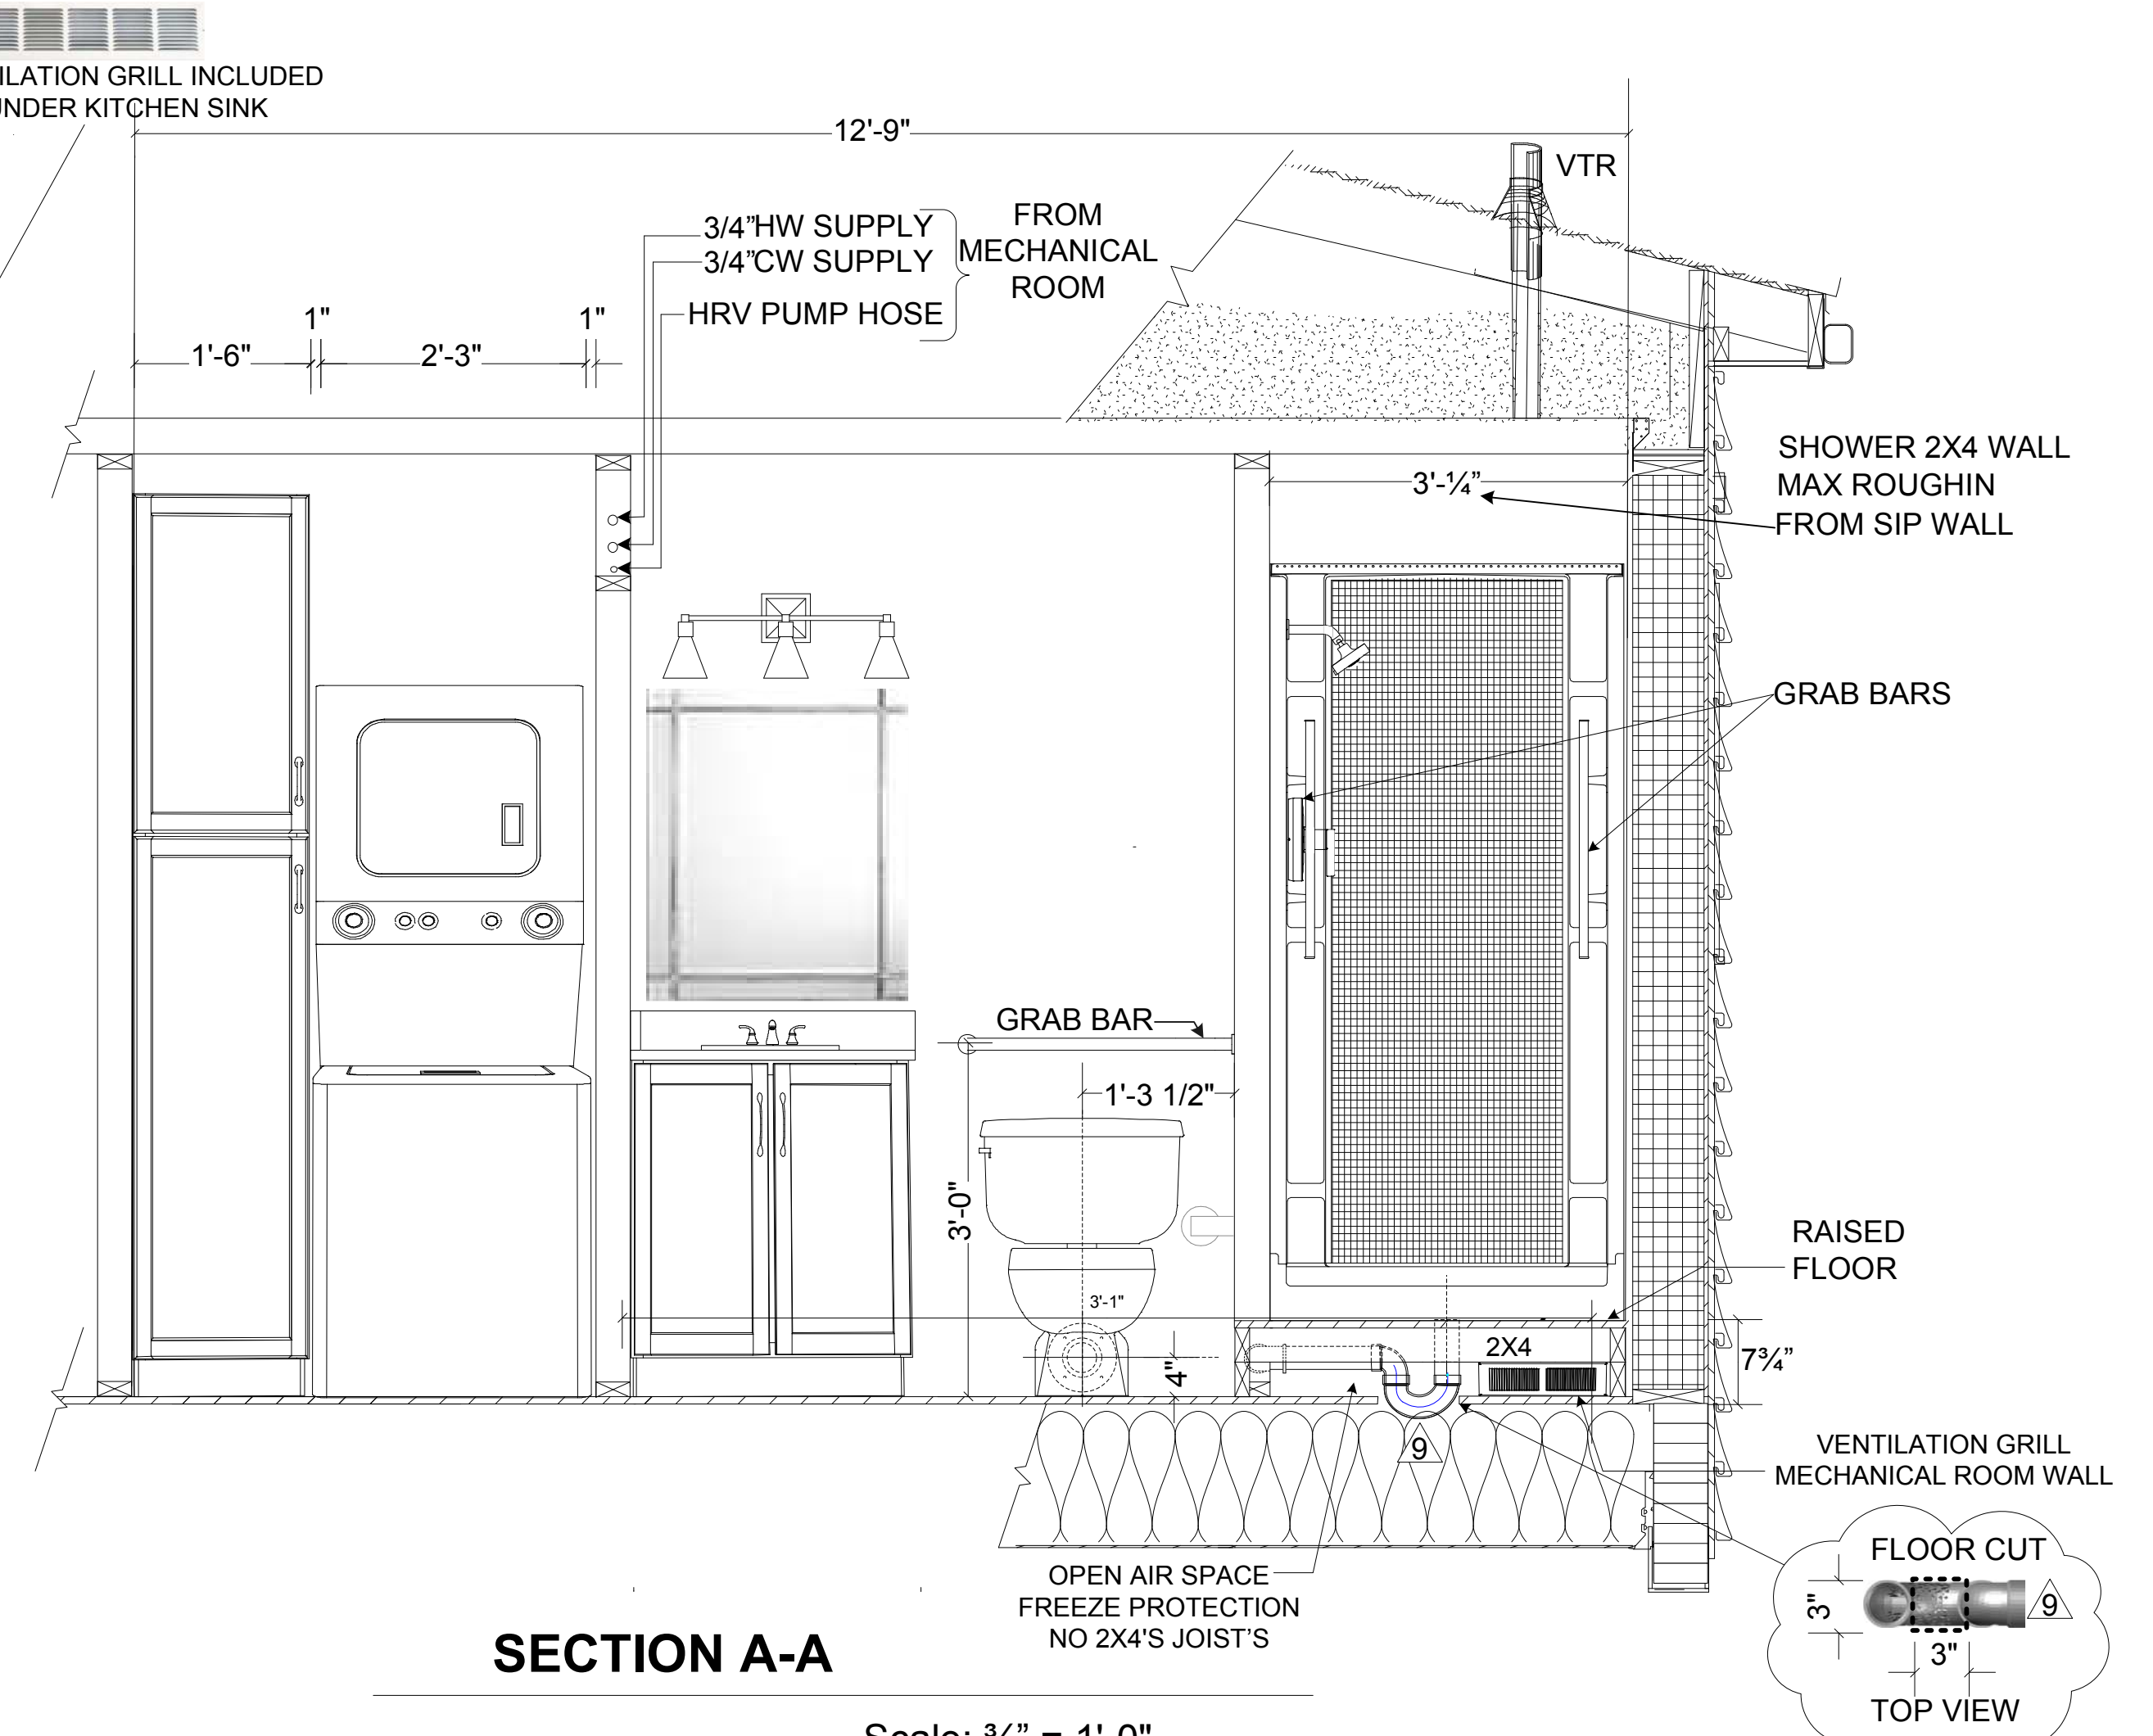

SECTION A-A
Scale: 3/4" = 1'-0"

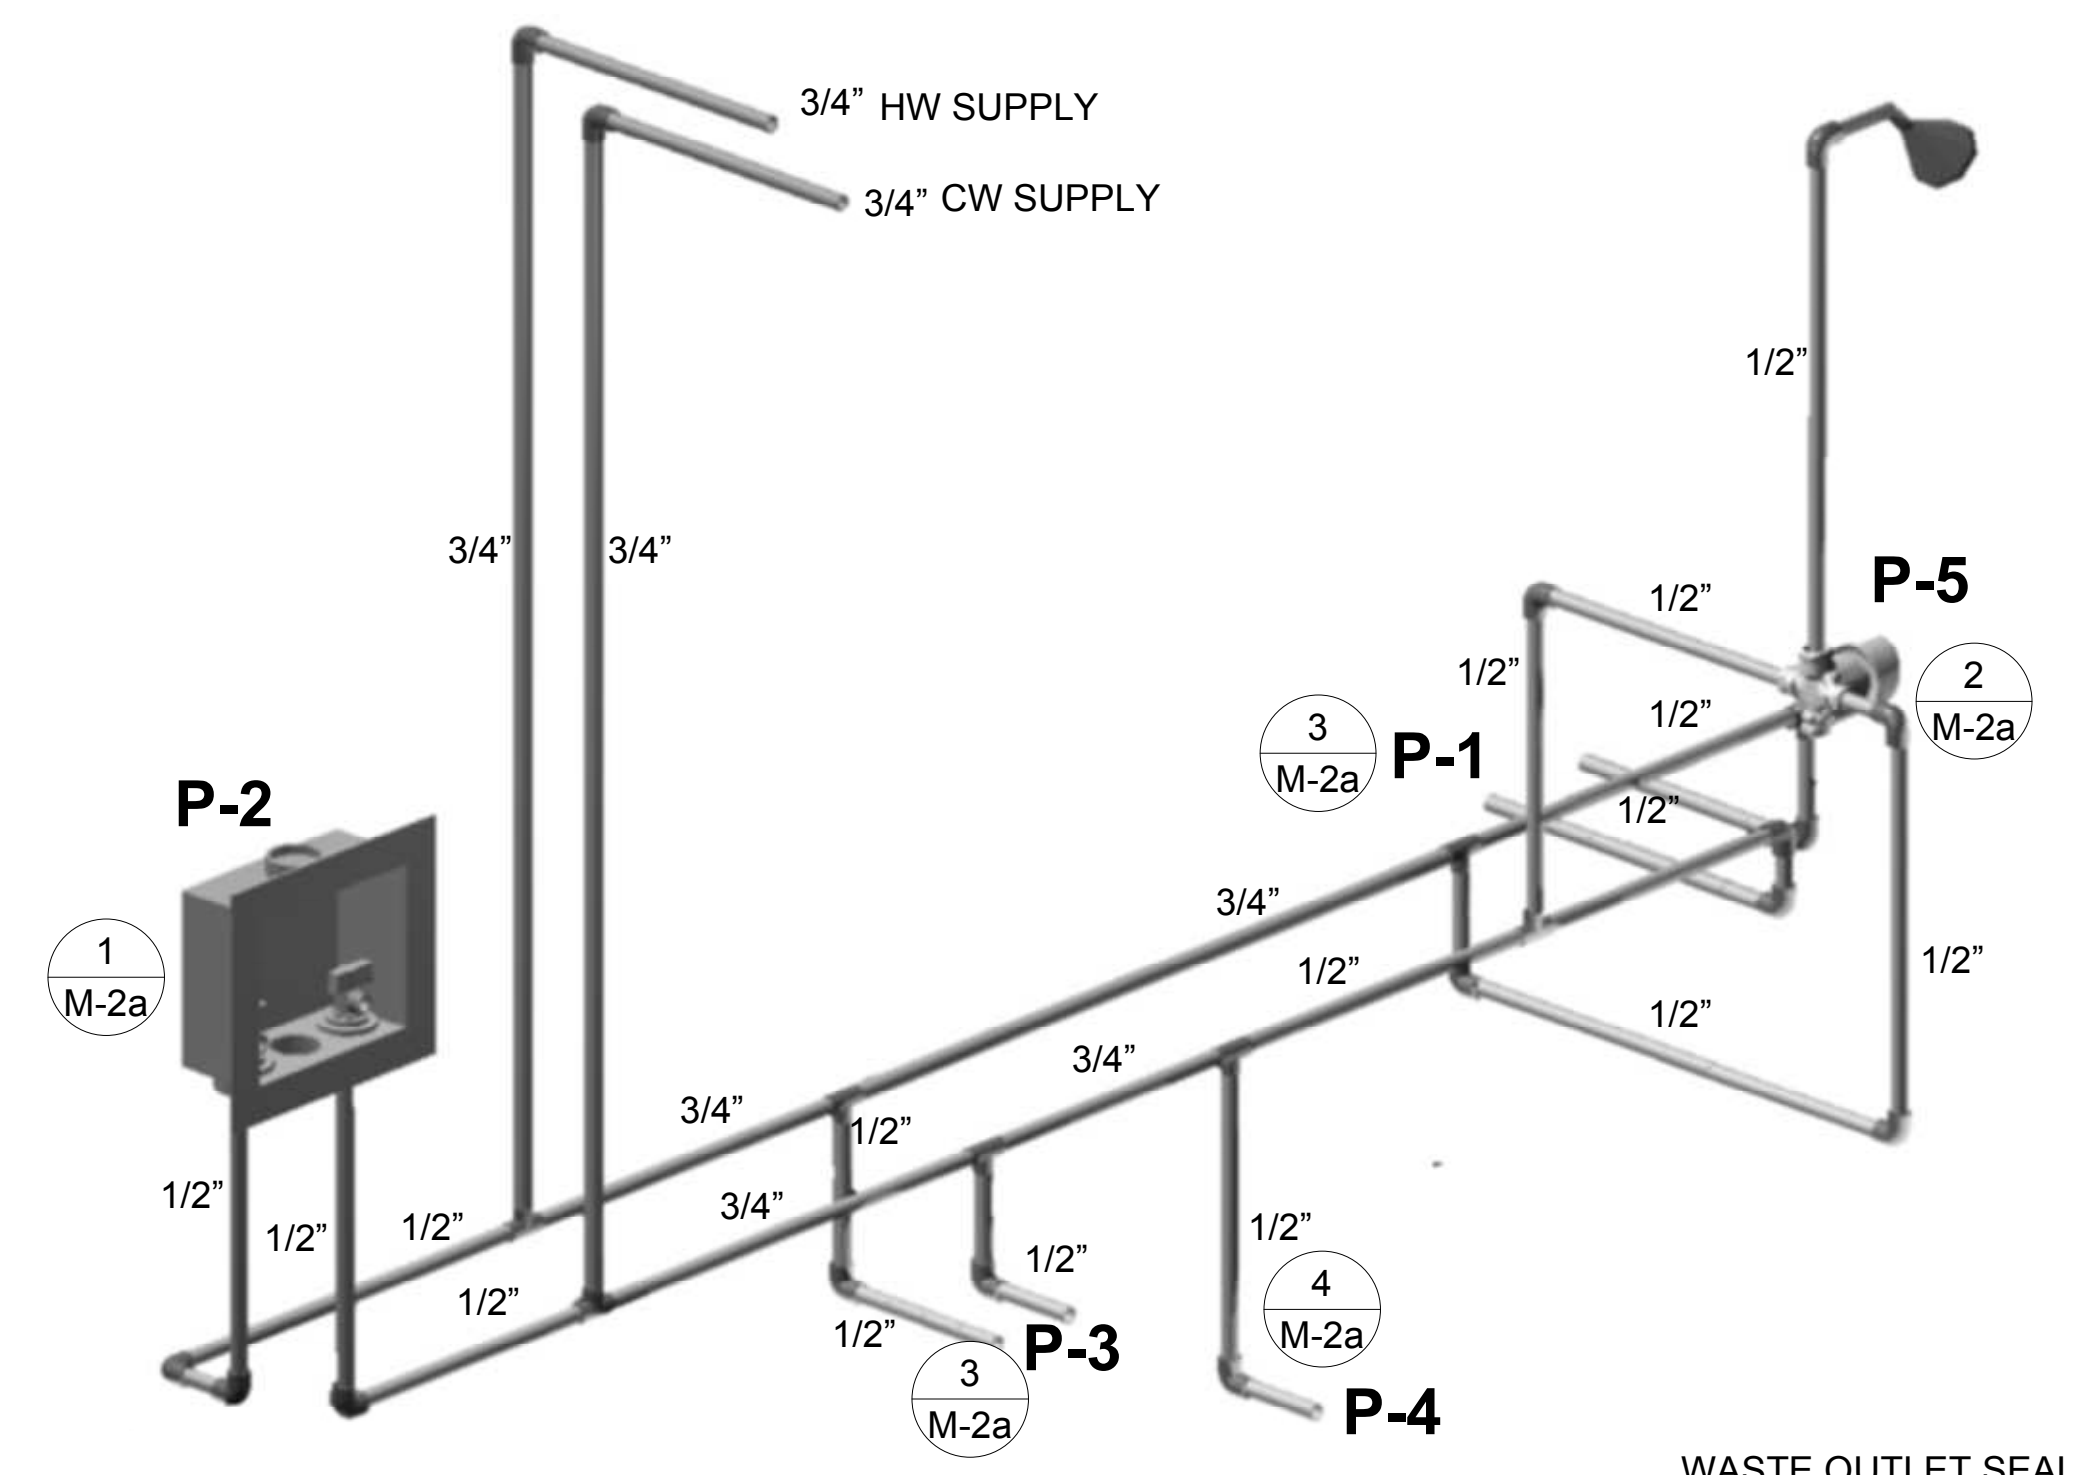


4 DOMESTIC WATER ISOMETRIC
UPONOR PROPEX BRASS FITTINGS NTS

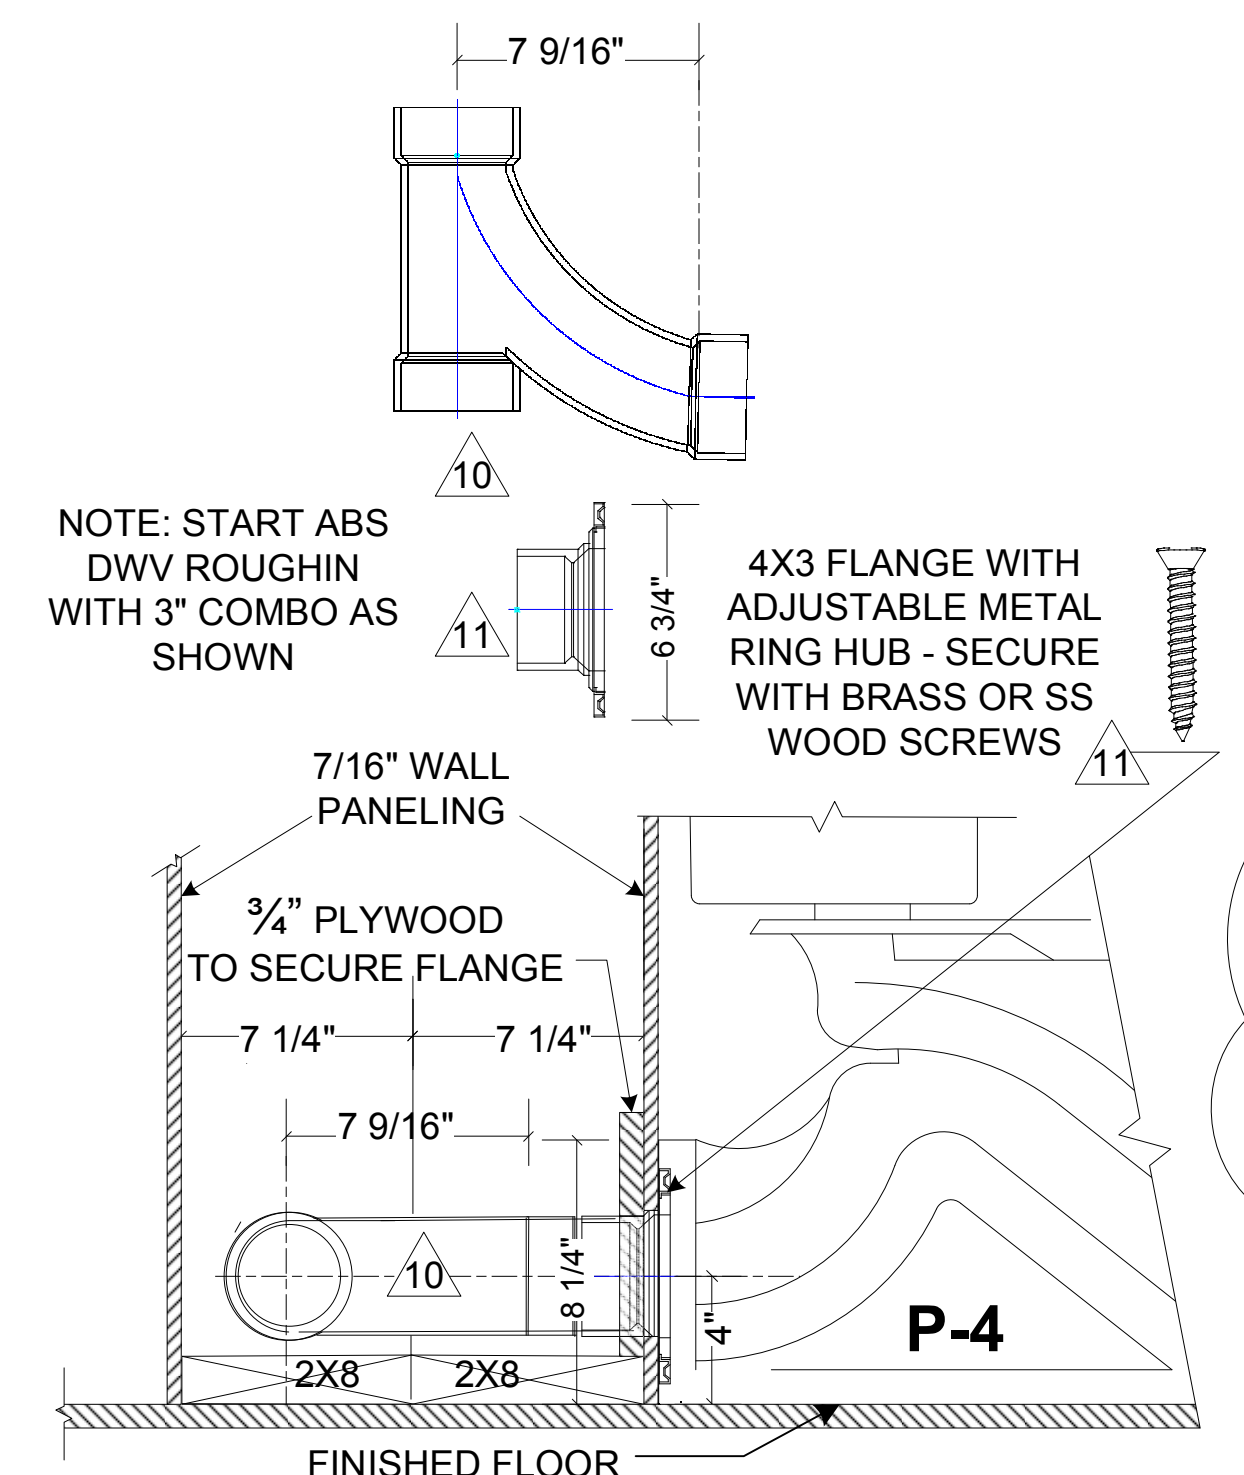

3 DWV START POINT ROUGHIN DETAILS
SCALE: 2" = 1'-0"

WASTE OUTLET SEAL RING MUST BE NEOPRENE OR GRAPHITEFELT (WAX RING NOT RECOMMENDED).

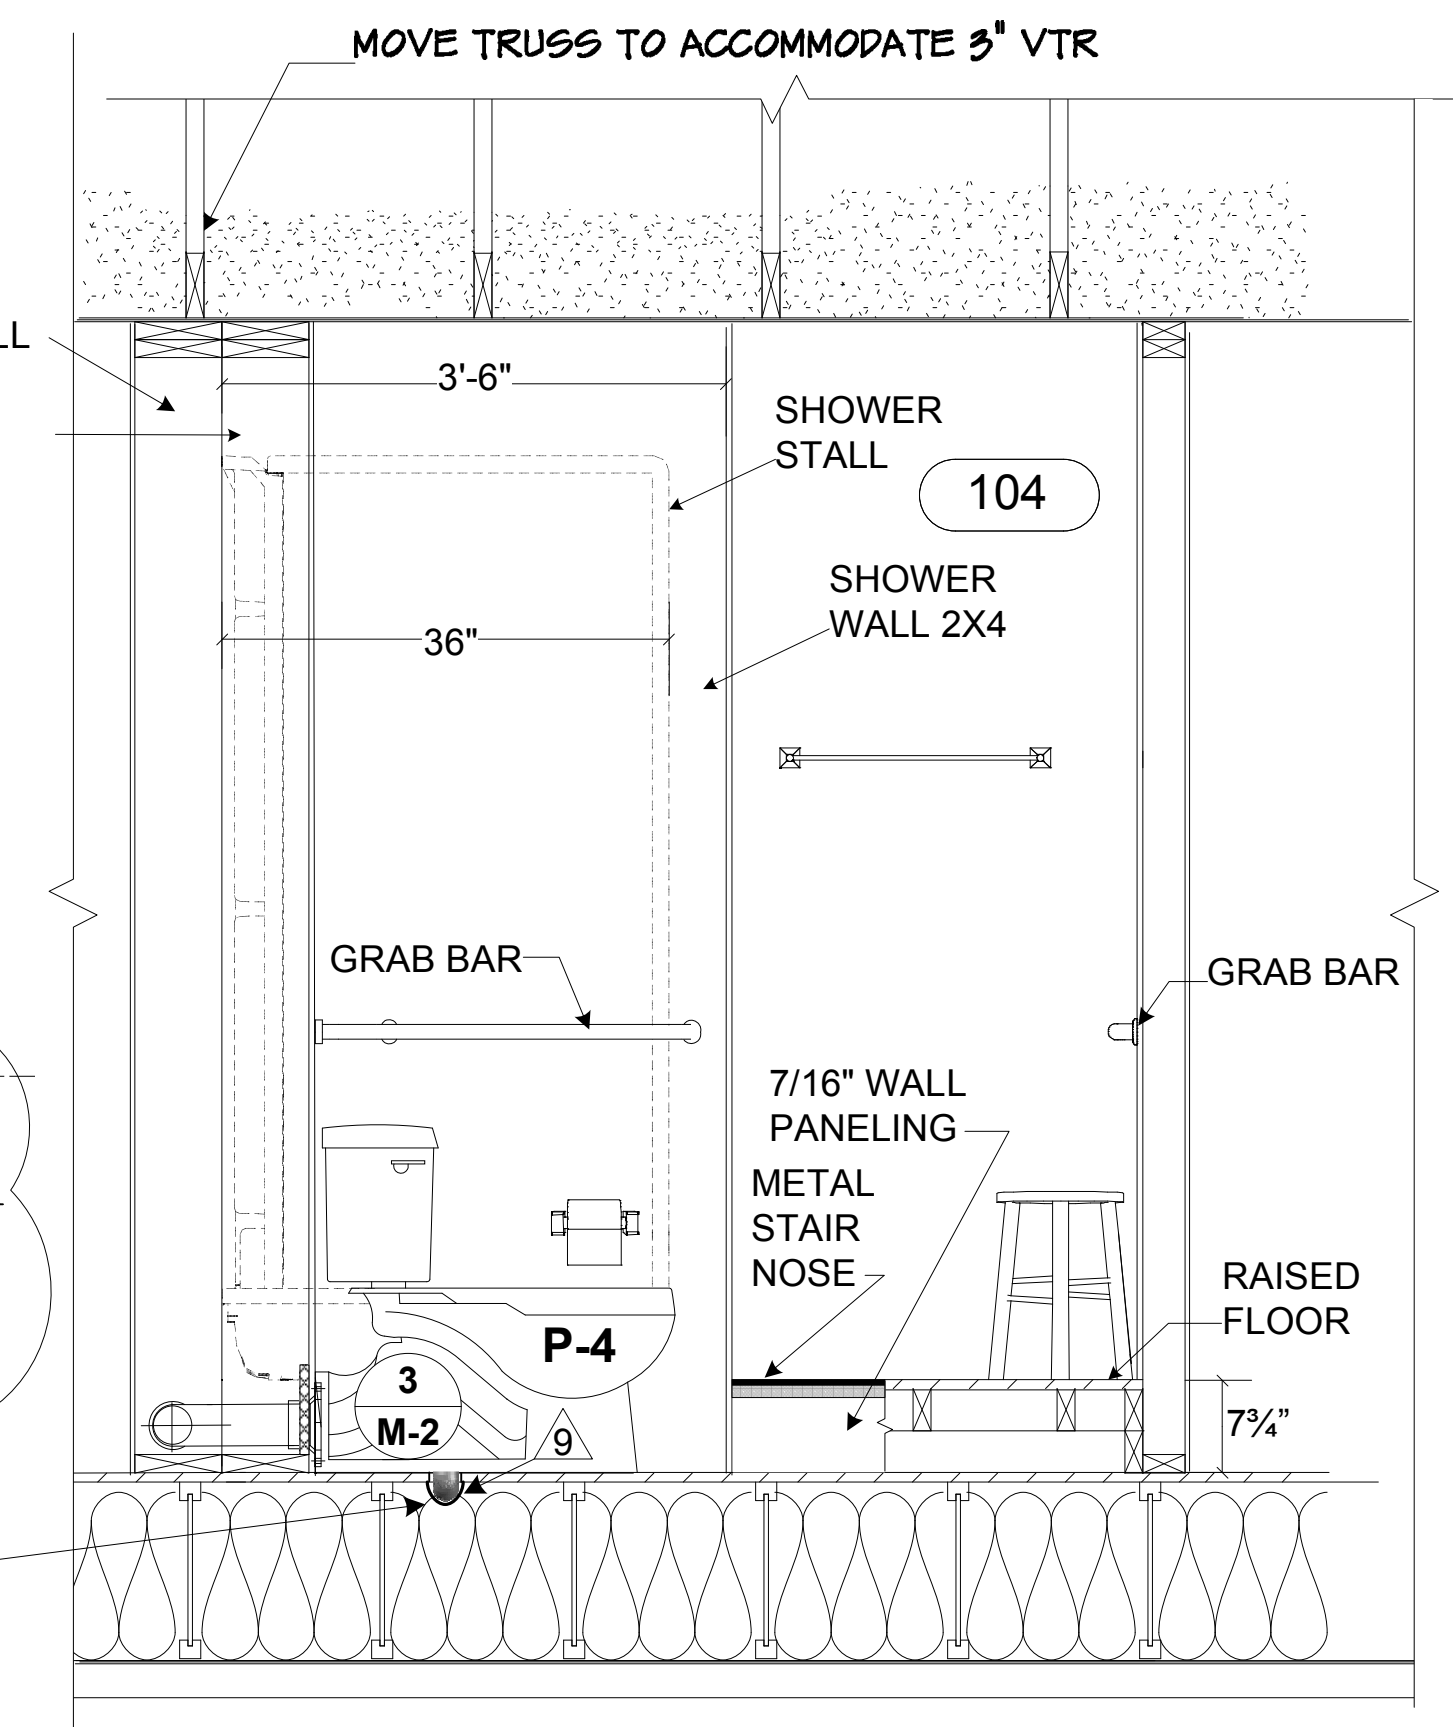

SECTION B-B
Scale: 3/4" = 1'-0"

PROJECT DEMONSTRATION & MONITORING PROJECT FOR AIR SOURCE HEAT PUMPS

FIXTURES, WASTE, VENTS & WATER ISOMETRIC



Scale: Per Detail
Design/drawn by jn
Mechanical Administrator
Date: 7/22/19

Category Sheet
M 2

No permission is given to duplicate or otherwise copy this mechanical drawing for any other purpose without the express permission of Ocean Air Contracting, LLC - ALL RIGHTS RESERVED

Revision: None

REVISION: None


None

REVISION

SYSTEM




1 P-2 OATEY WASH MACHINE BOX
M-2a WITH WATER HAMMER ARRESTOR

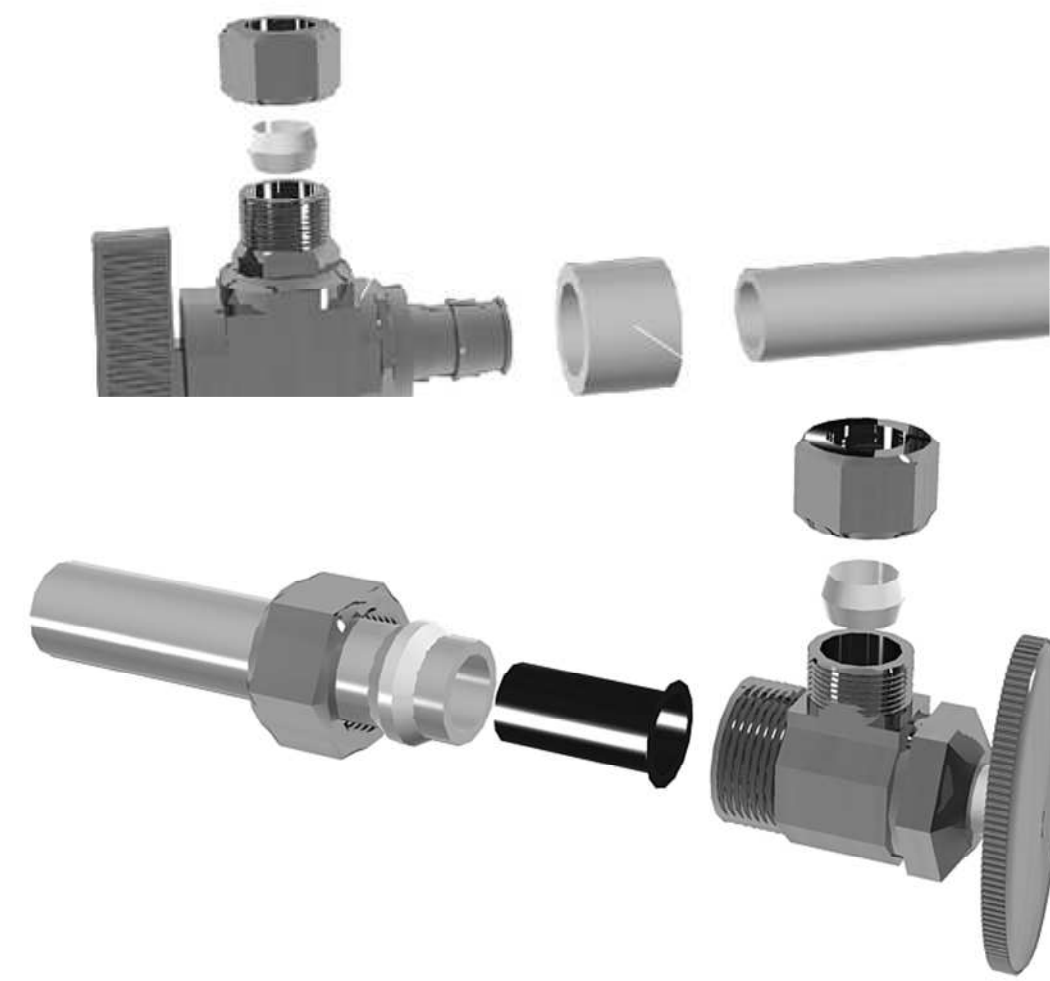


UPONOR ANGLE STOP CONNECTIONS




UPONOR BENDS

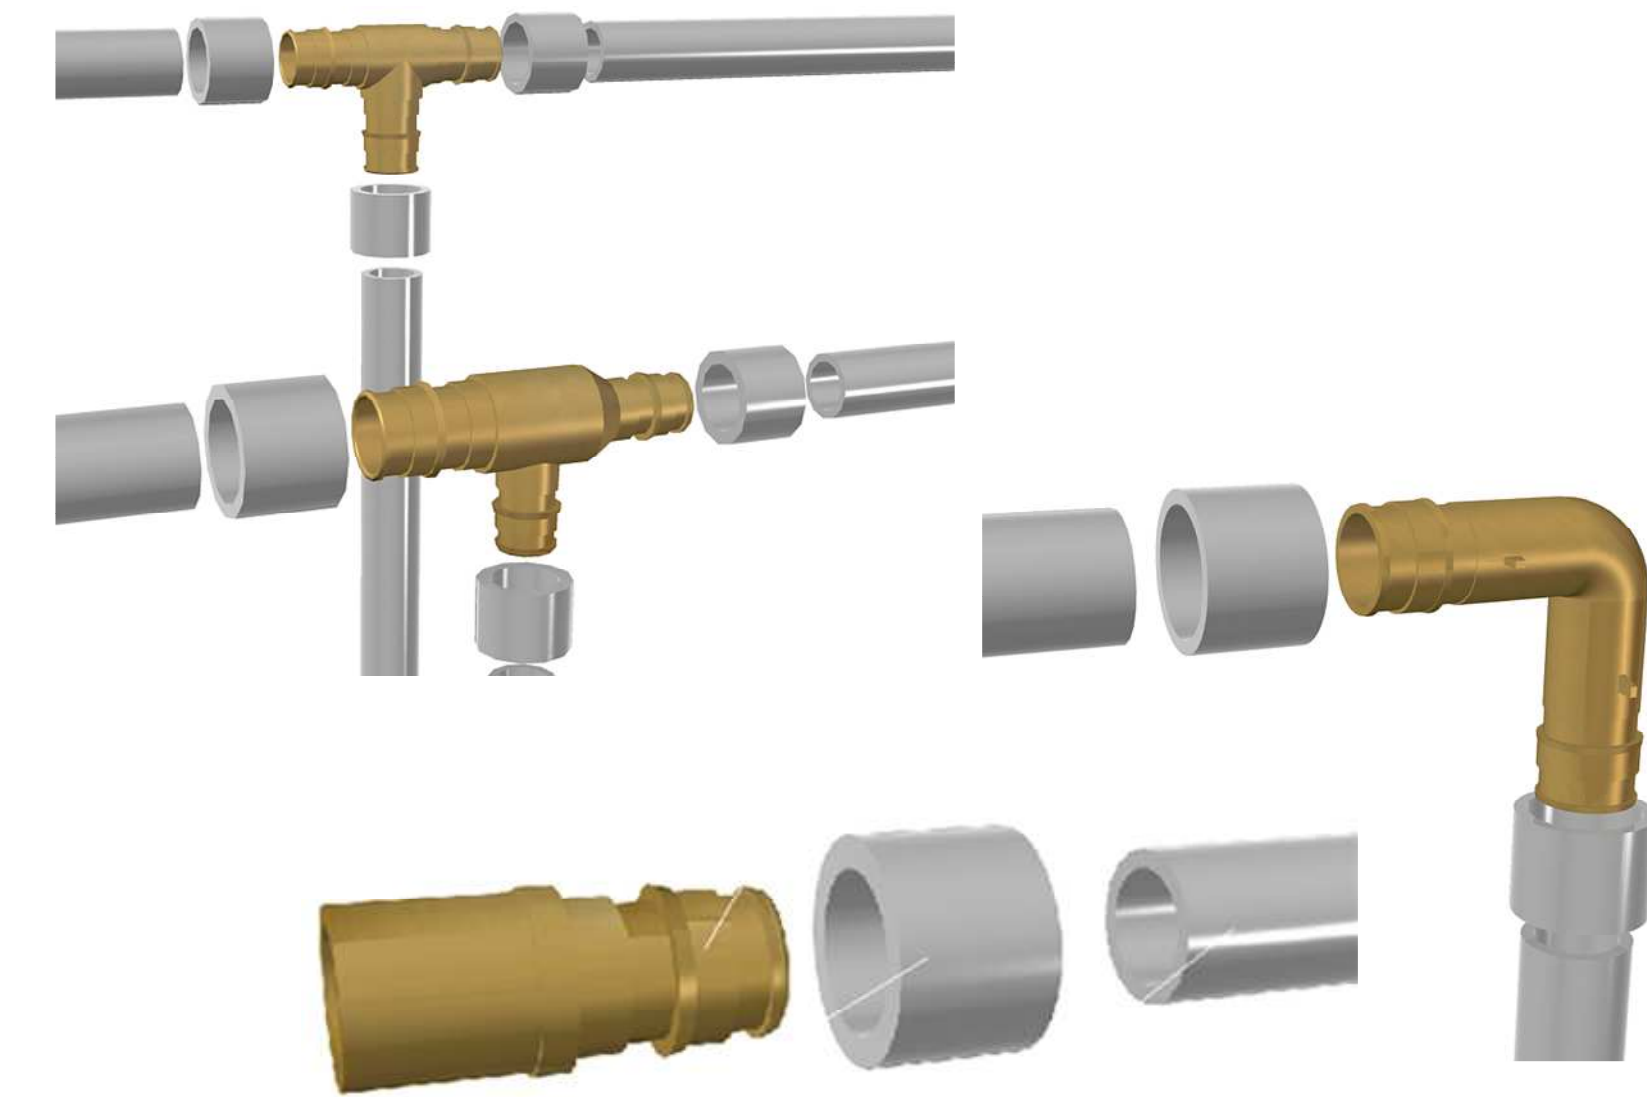


UPONOR PROPEX BRASS FITTINGS

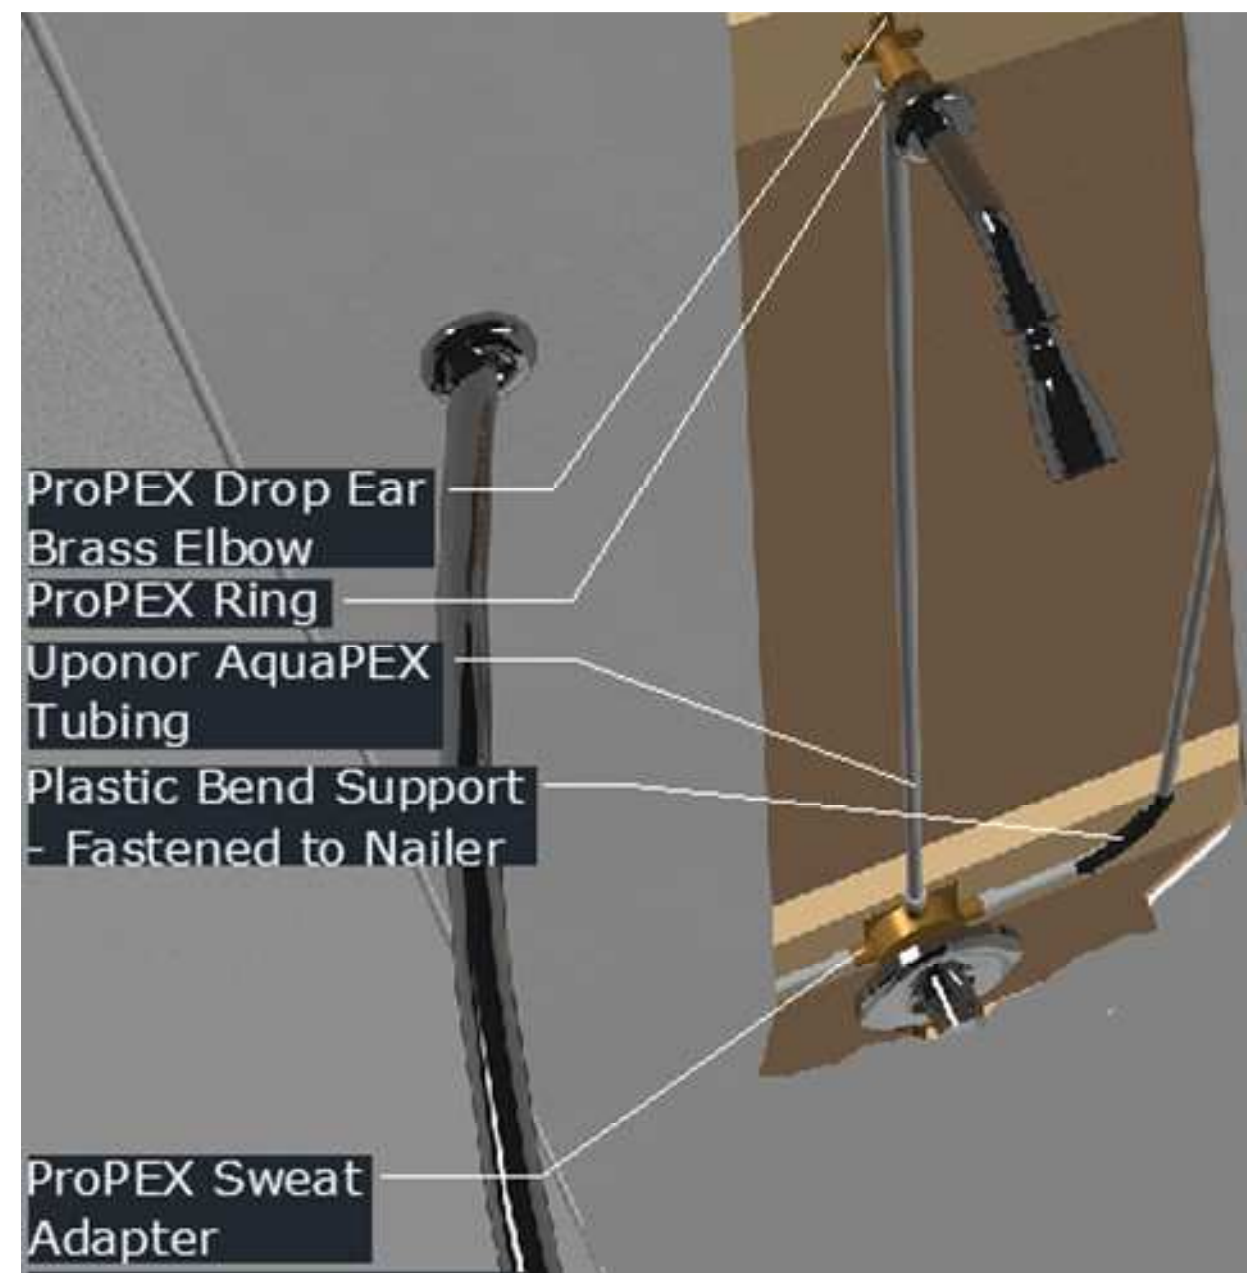


2 P-5 SHOWER DETAIL
M-2a

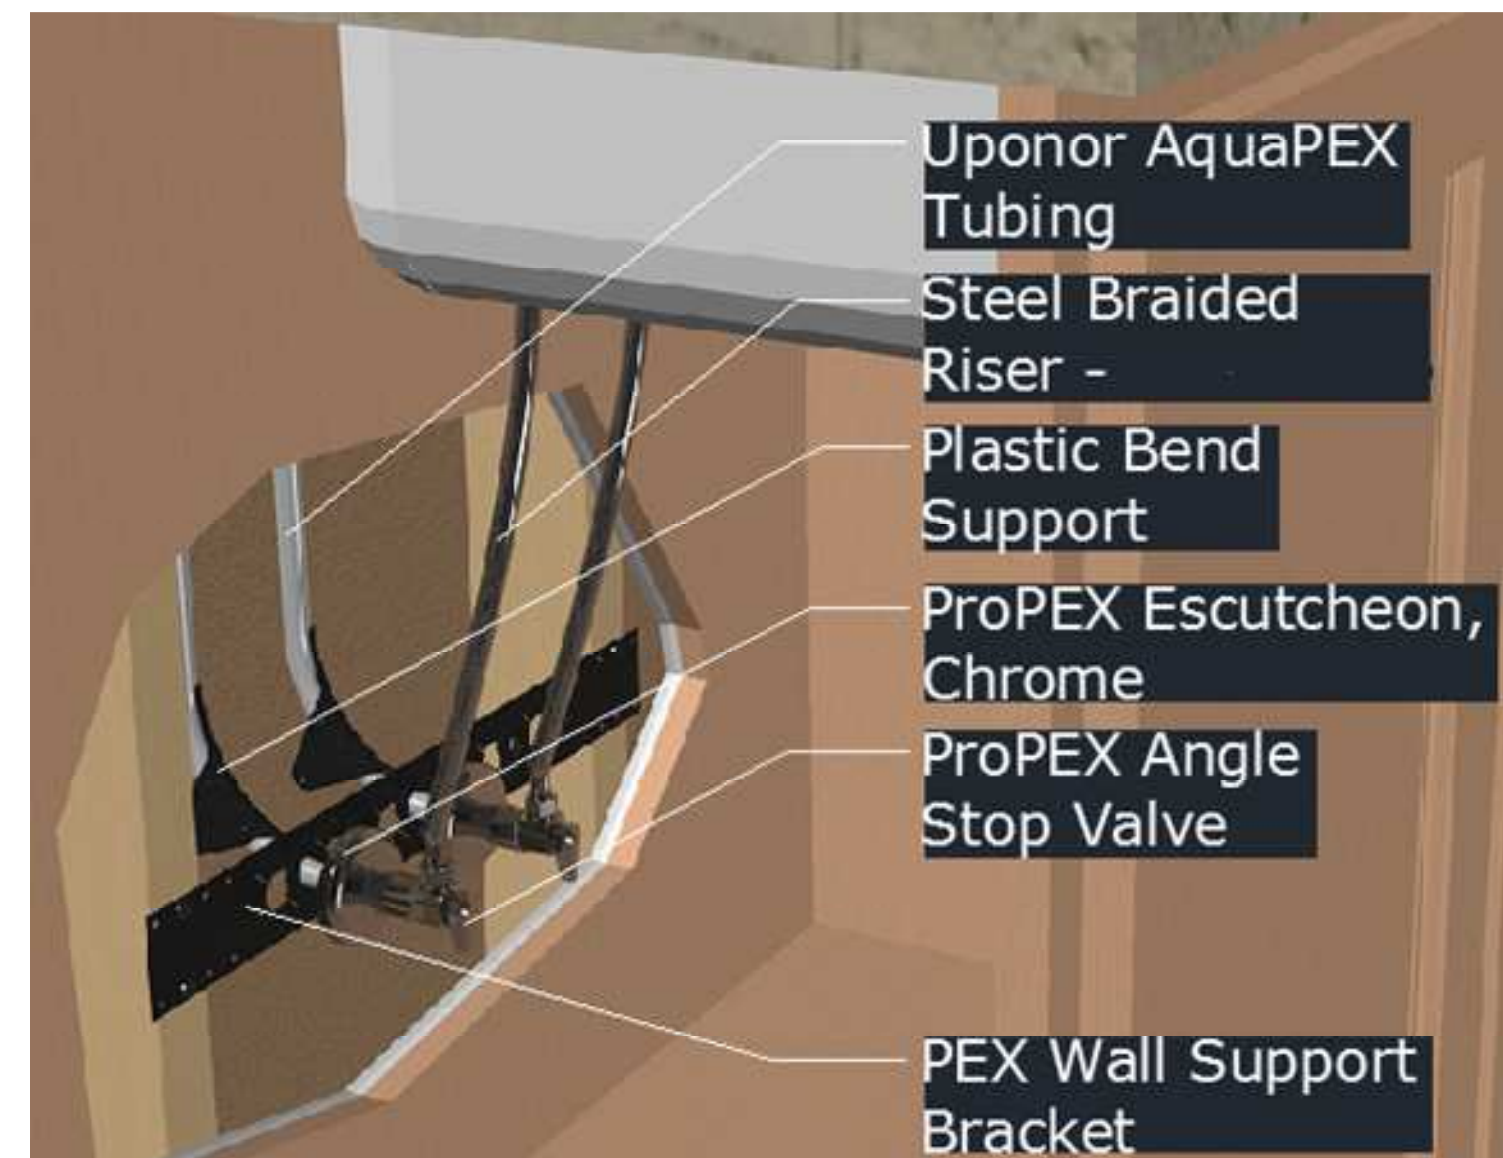

3 P-1 & 3 KITCHEN SINK & LAV DETAIL
M-2a

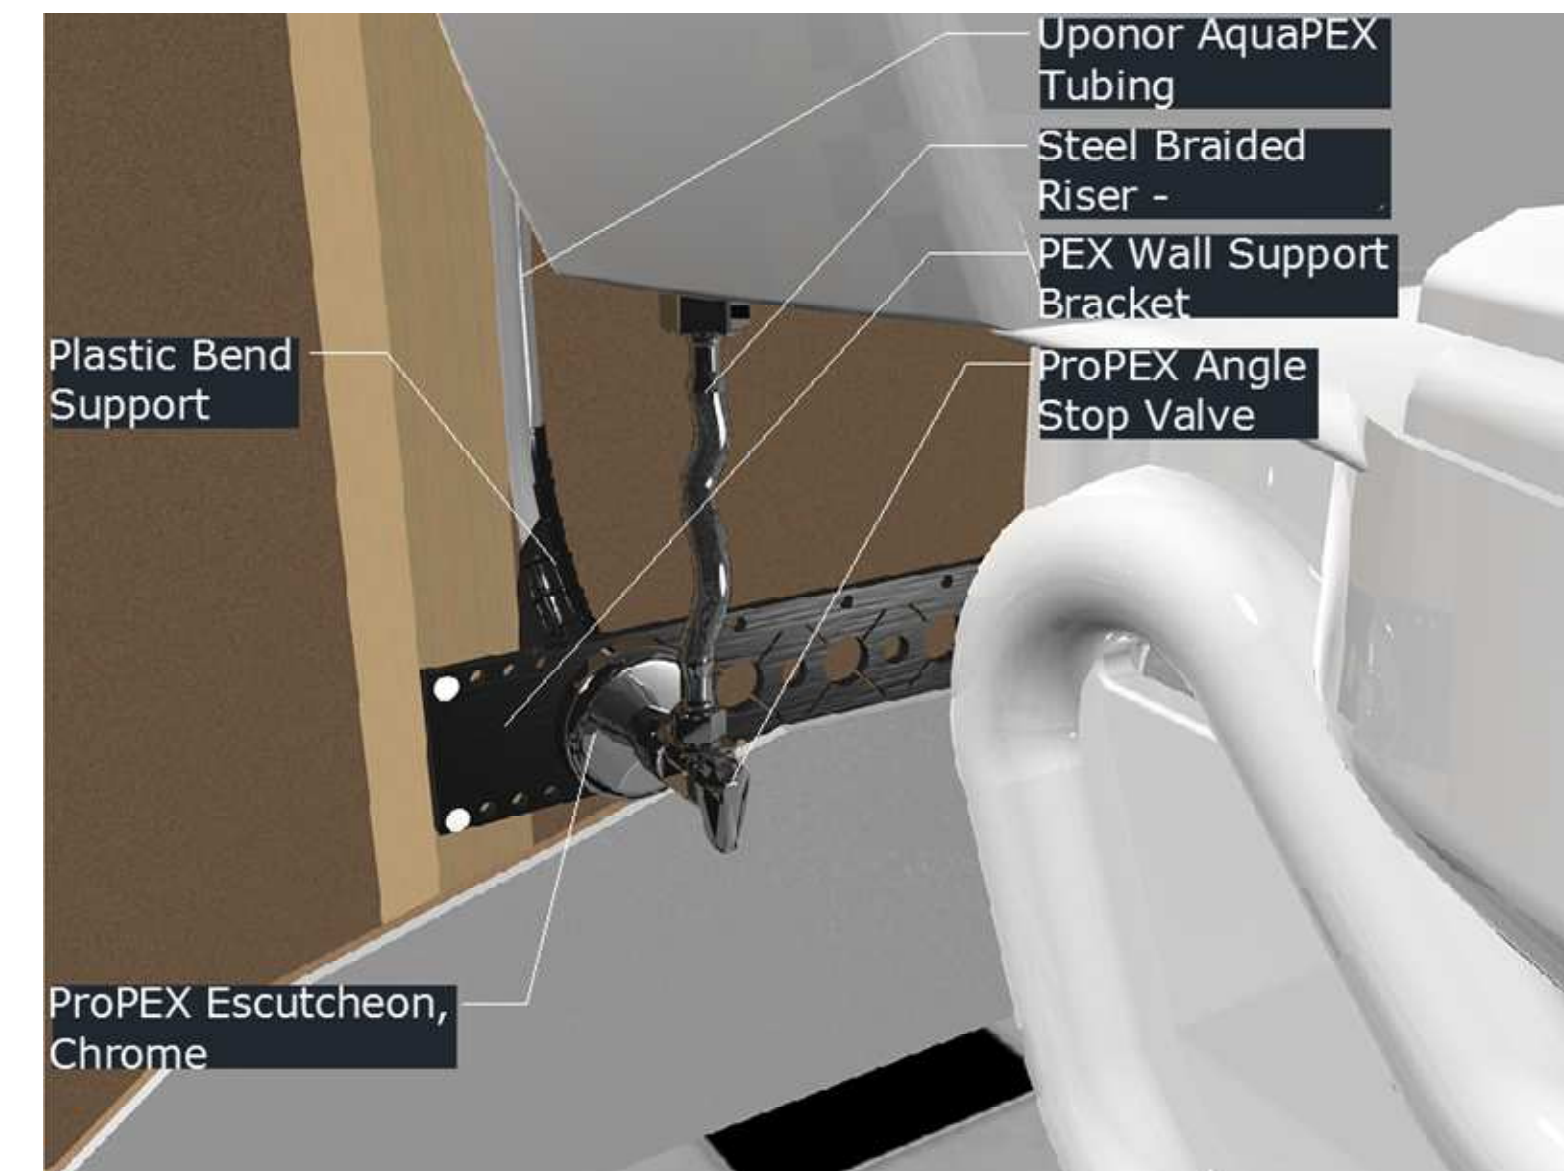

4 P-4 CLOSET DETAIL
M-2a

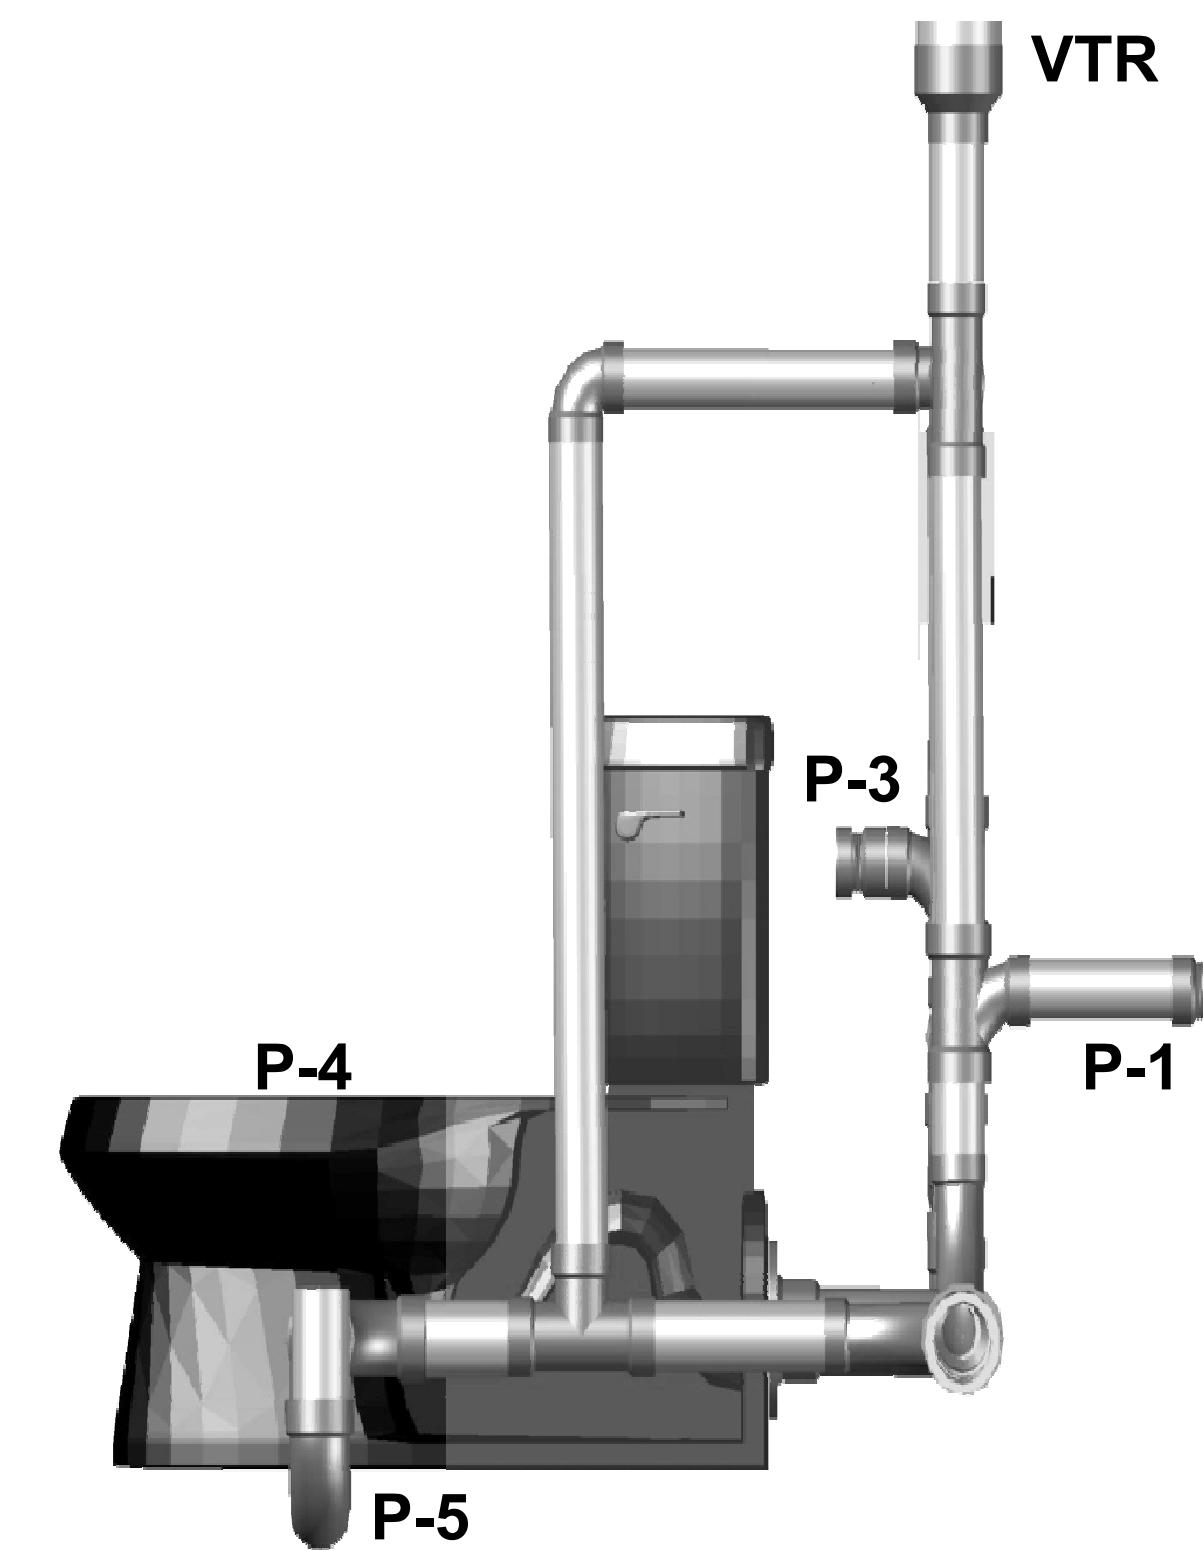

C-C SECTION C-C
M-2 3D VIEW DWG

UPONOR PROPEX PIPING SYSTEM

PROJECT DEMONSTRATION & MONITORING PROJECT FOR AIR SOURCE HEAT PUMPS

OWNER FIXTURE CONNECTION DETAILS

No permission is given to duplicate or otherwise copy this mechanical drawing for any other purpose without the express permission of Ocean Air Contracting, LLC - ALL RIGHTS RESERVED

REVISION: None

None

REVISION



Scale: per detail

Design/Drawn by: jn

Date: 7/22/19

Job No. Bethel Demo


Contents:

Category	Sheet
----------	-------


M 3




1 SOLAR HW HEATER & CONTROLLER (CP-2)
Scale: n/a

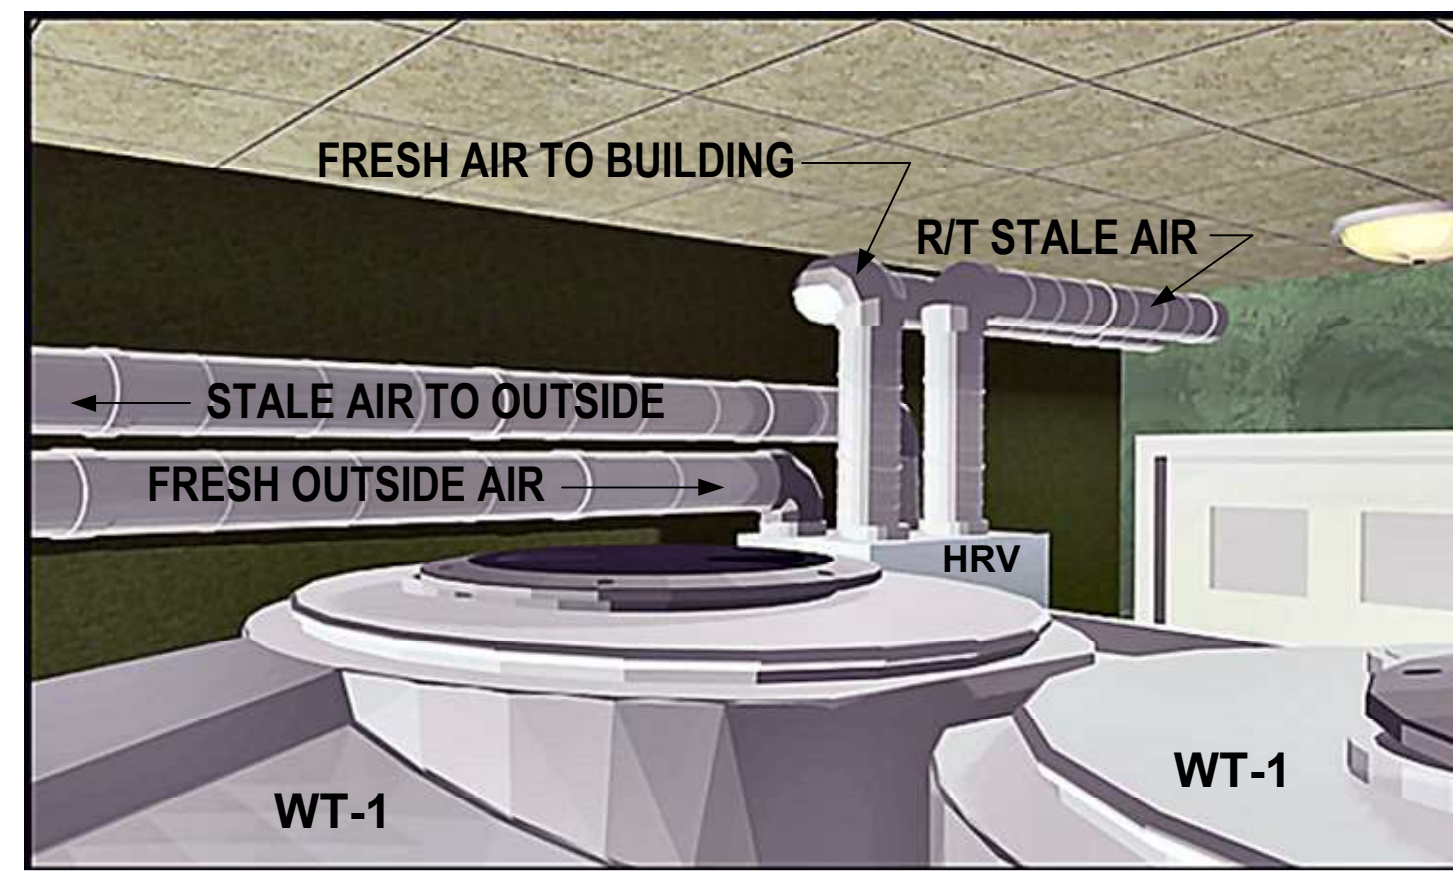


2 HRV VENTILATION DUCTS
Scale: n/a

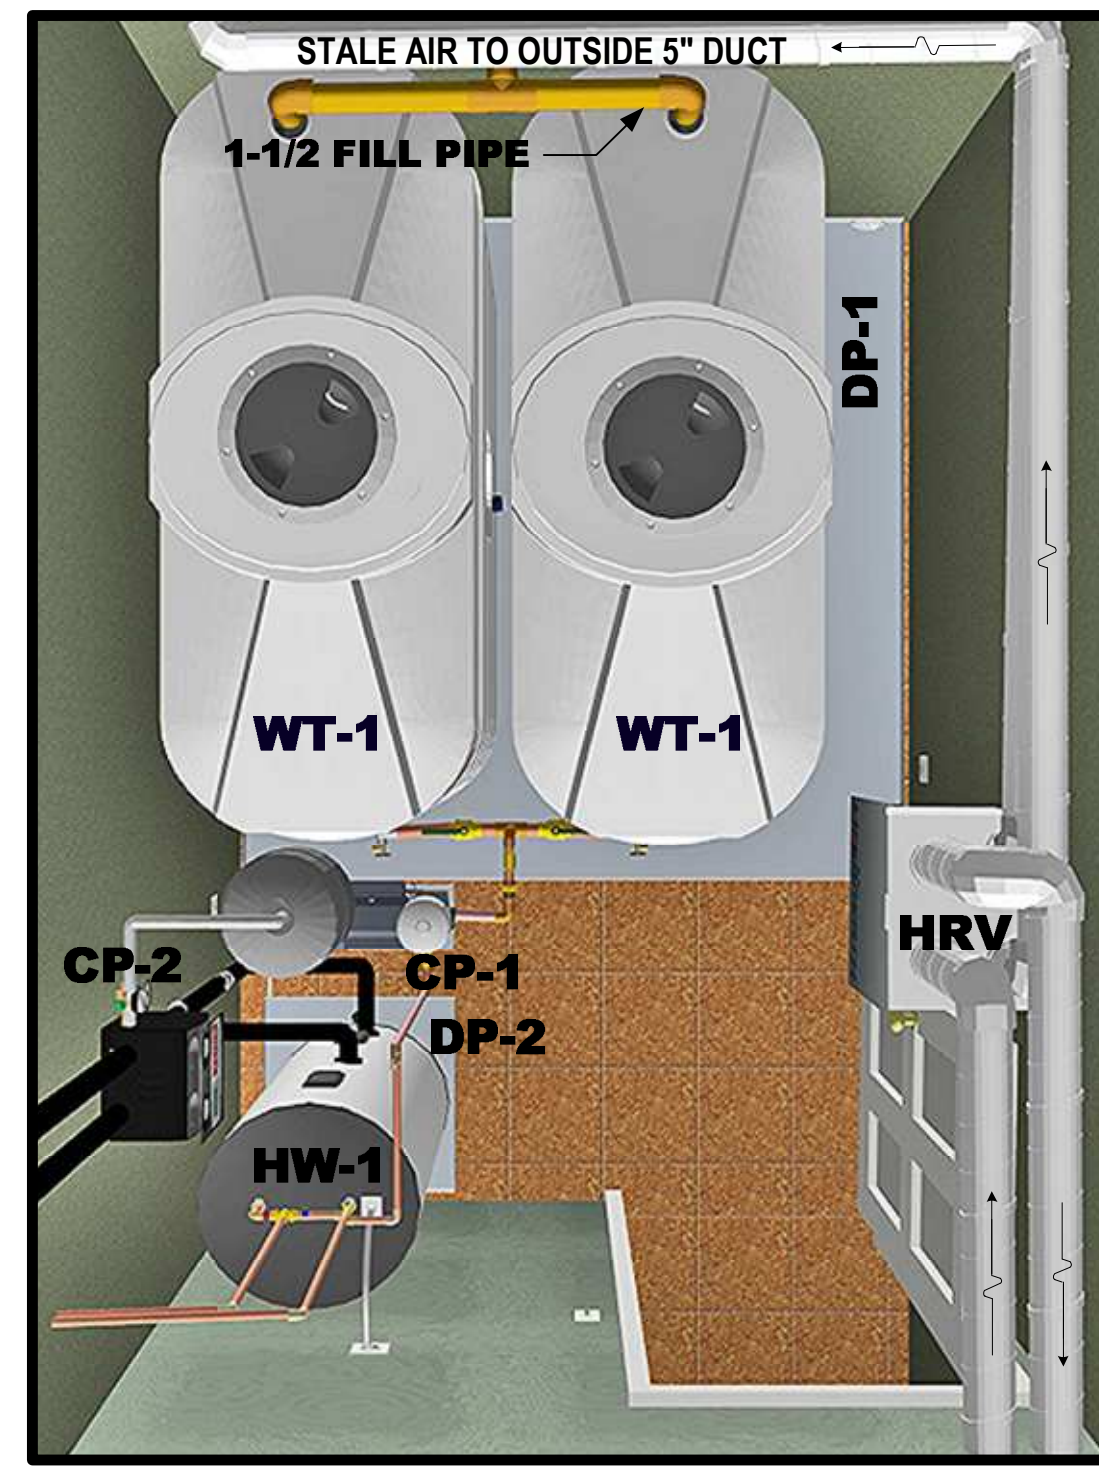


3D MECHANICAL ROOM FLOOR PLAN
Scale: n/a

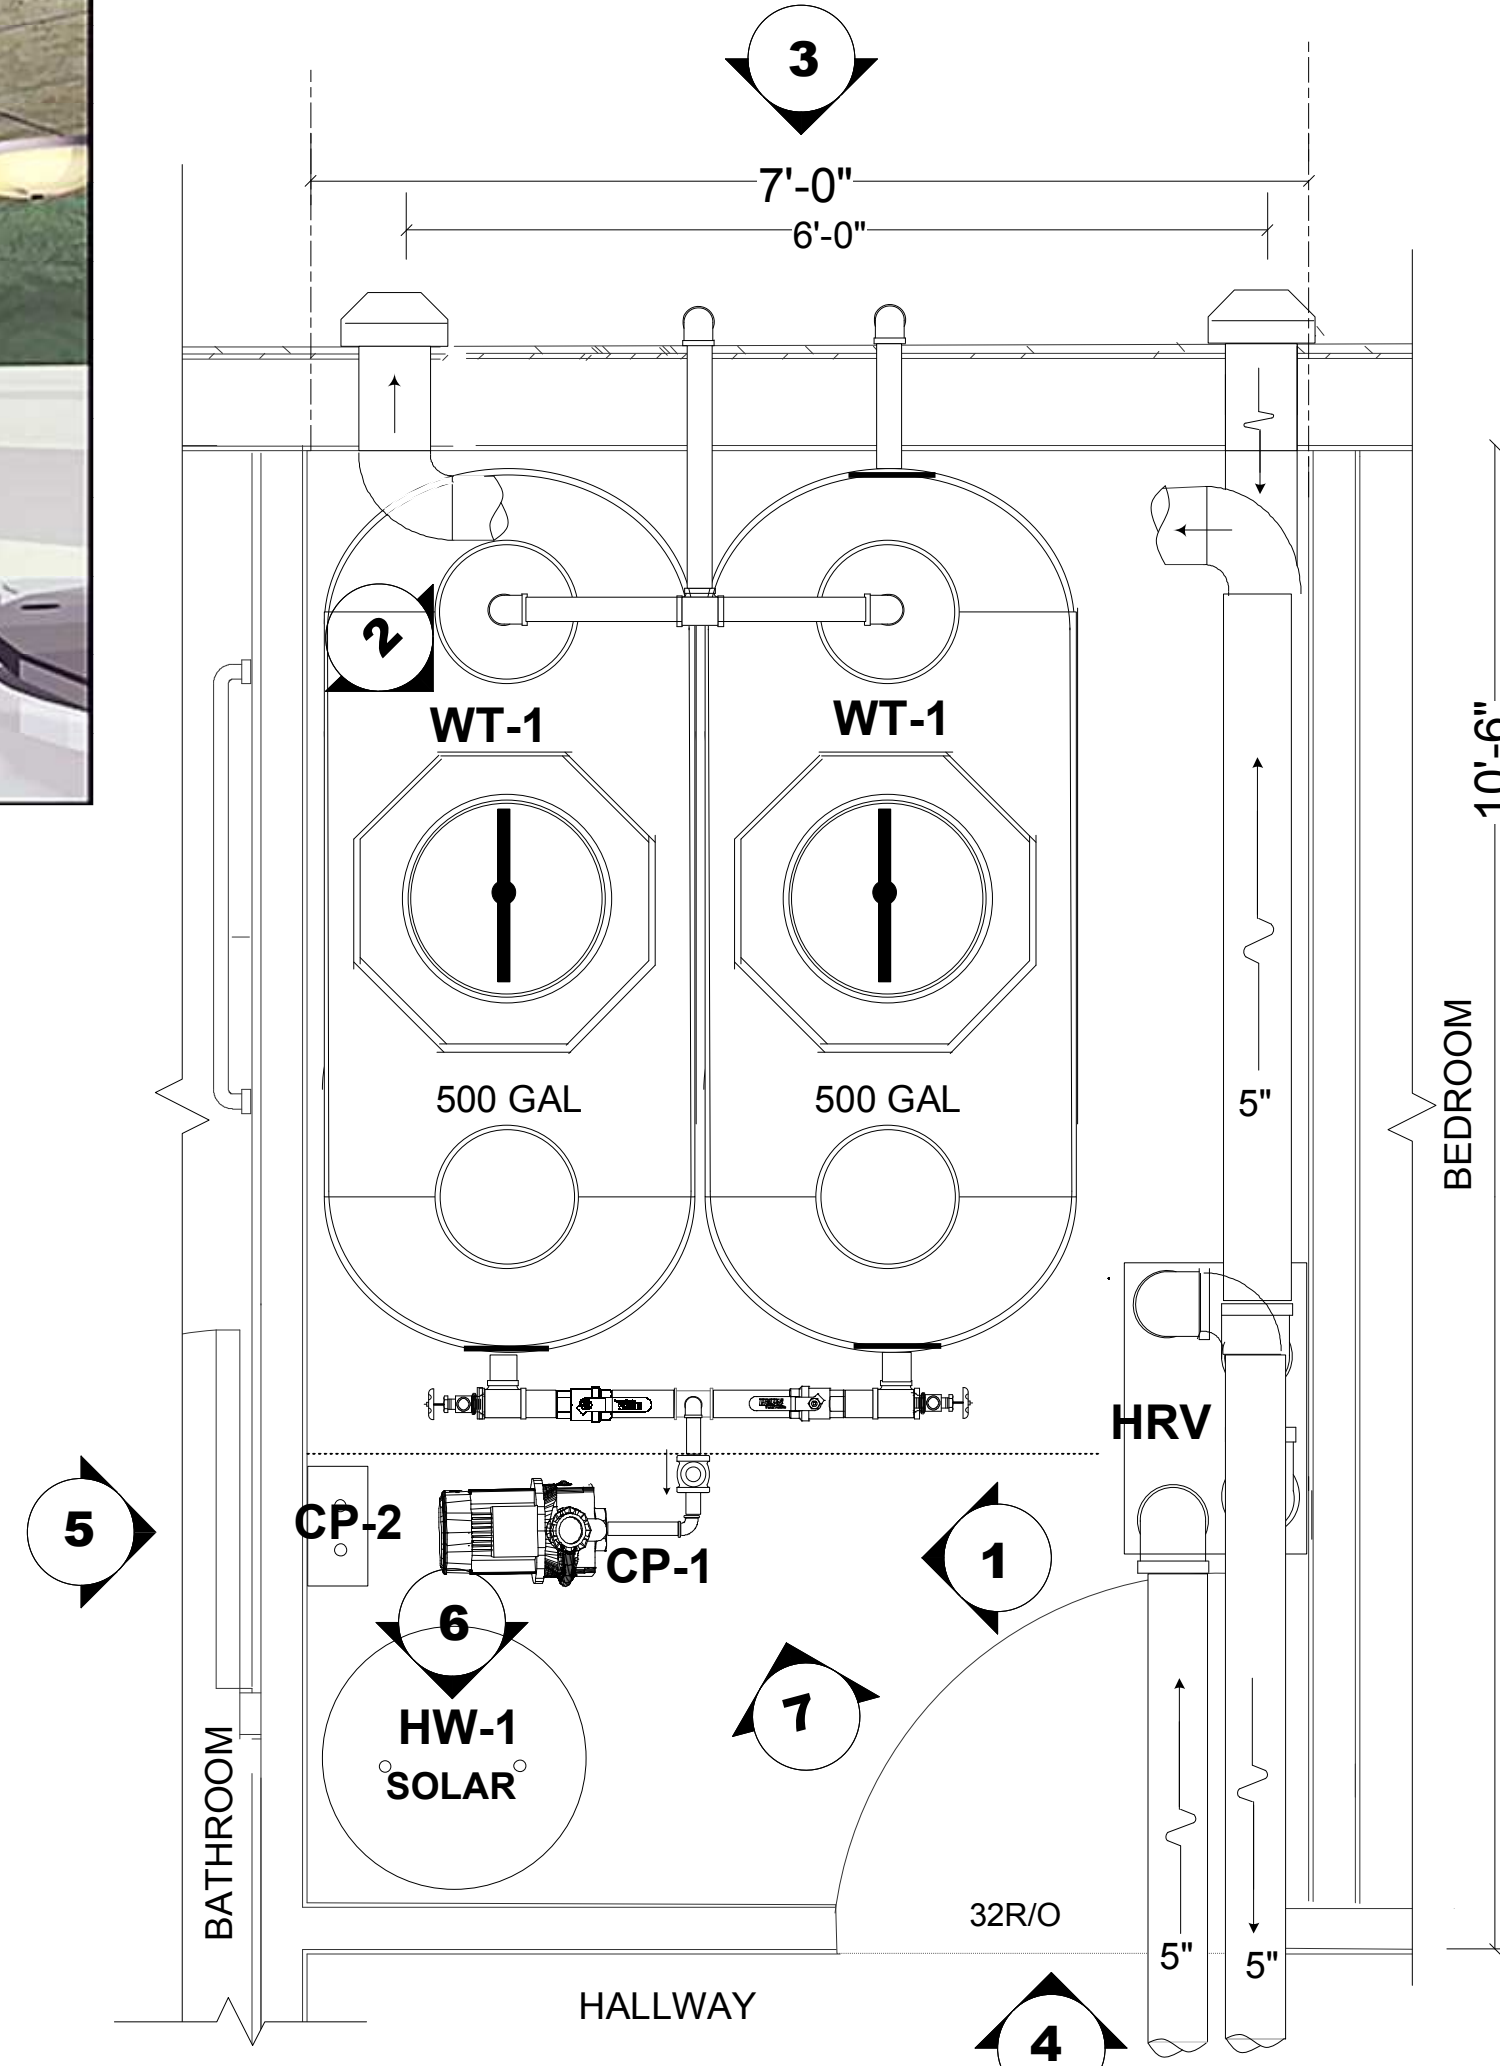


1 MECHANICAL ROOM FLOOR PLAN
M4 Scale: 3/4" = 1'-0"

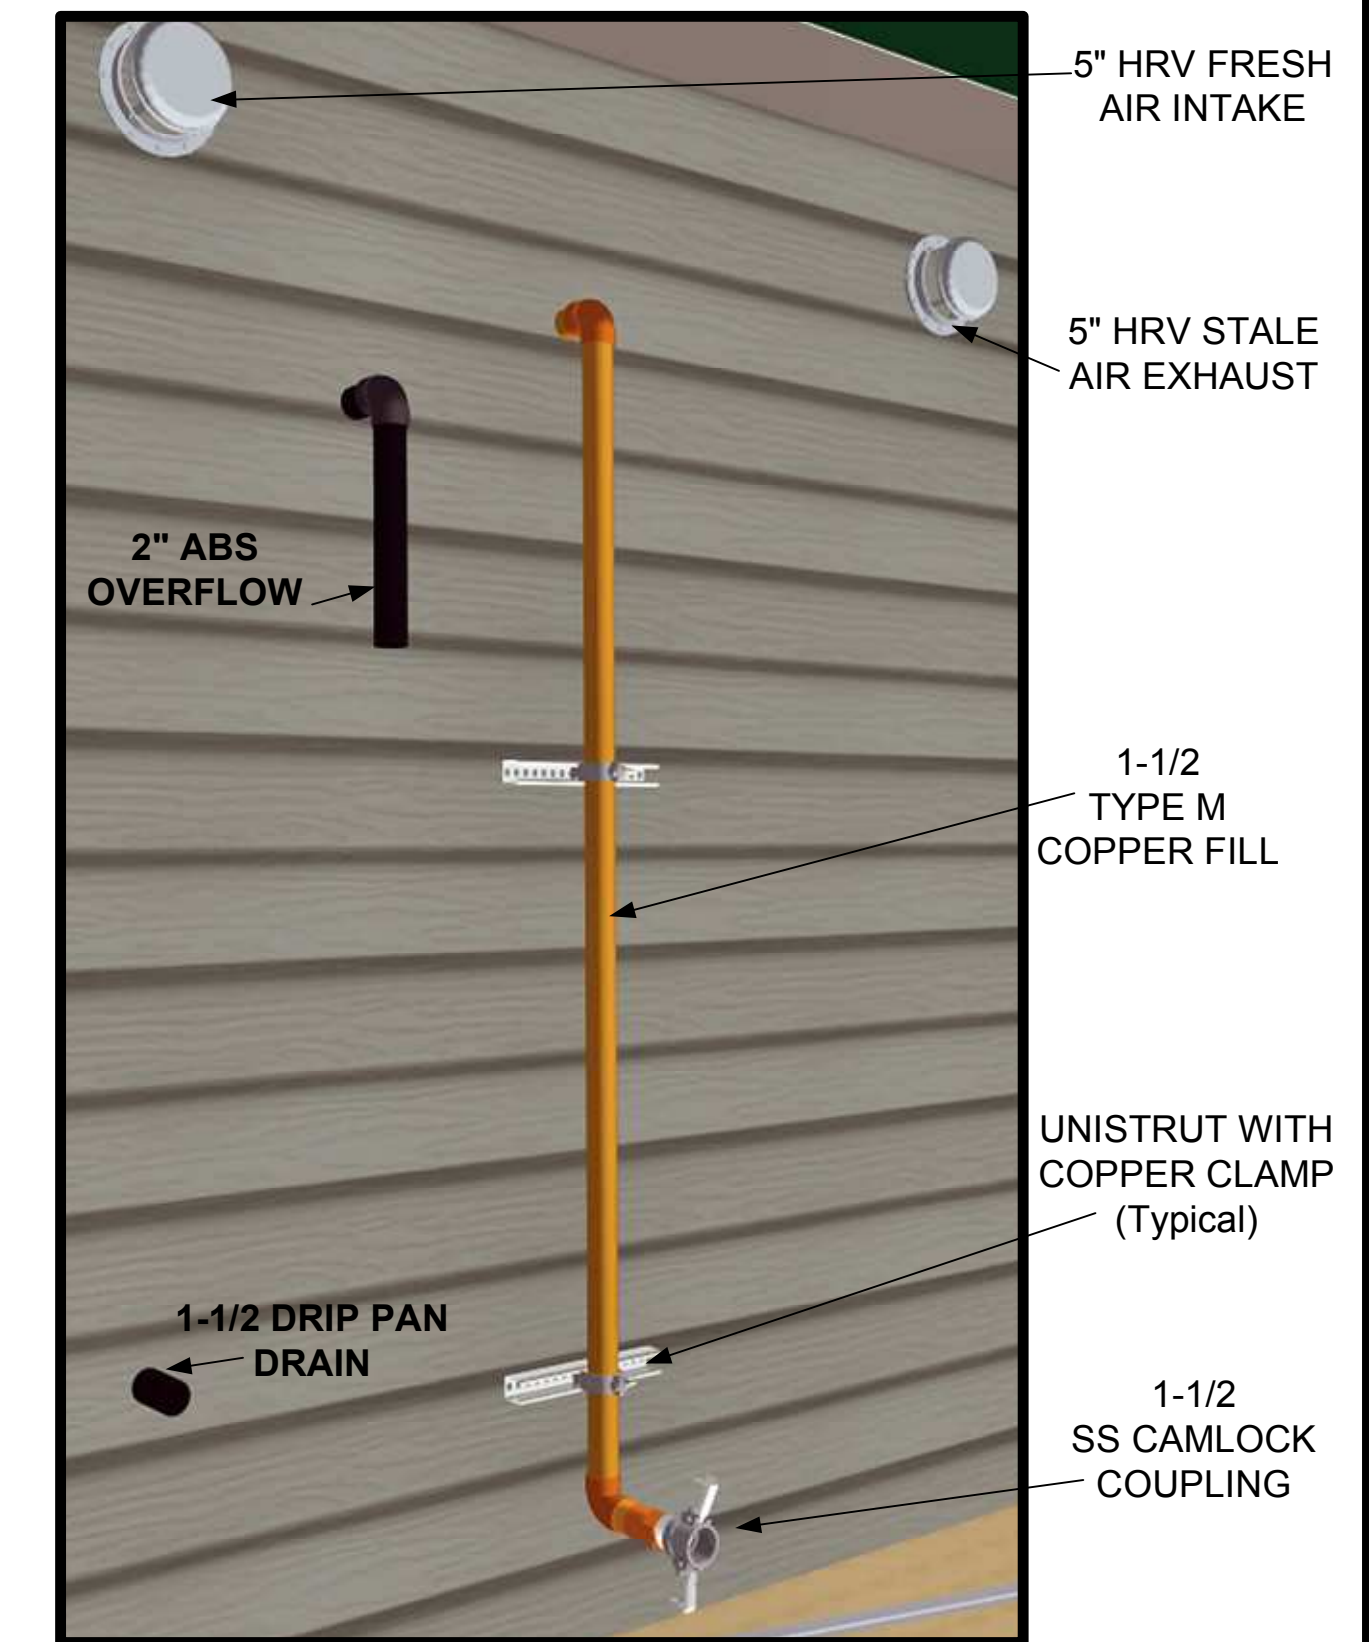


3 WATER FILL & OVERFLOW EXTERIOR
Scale: n/a

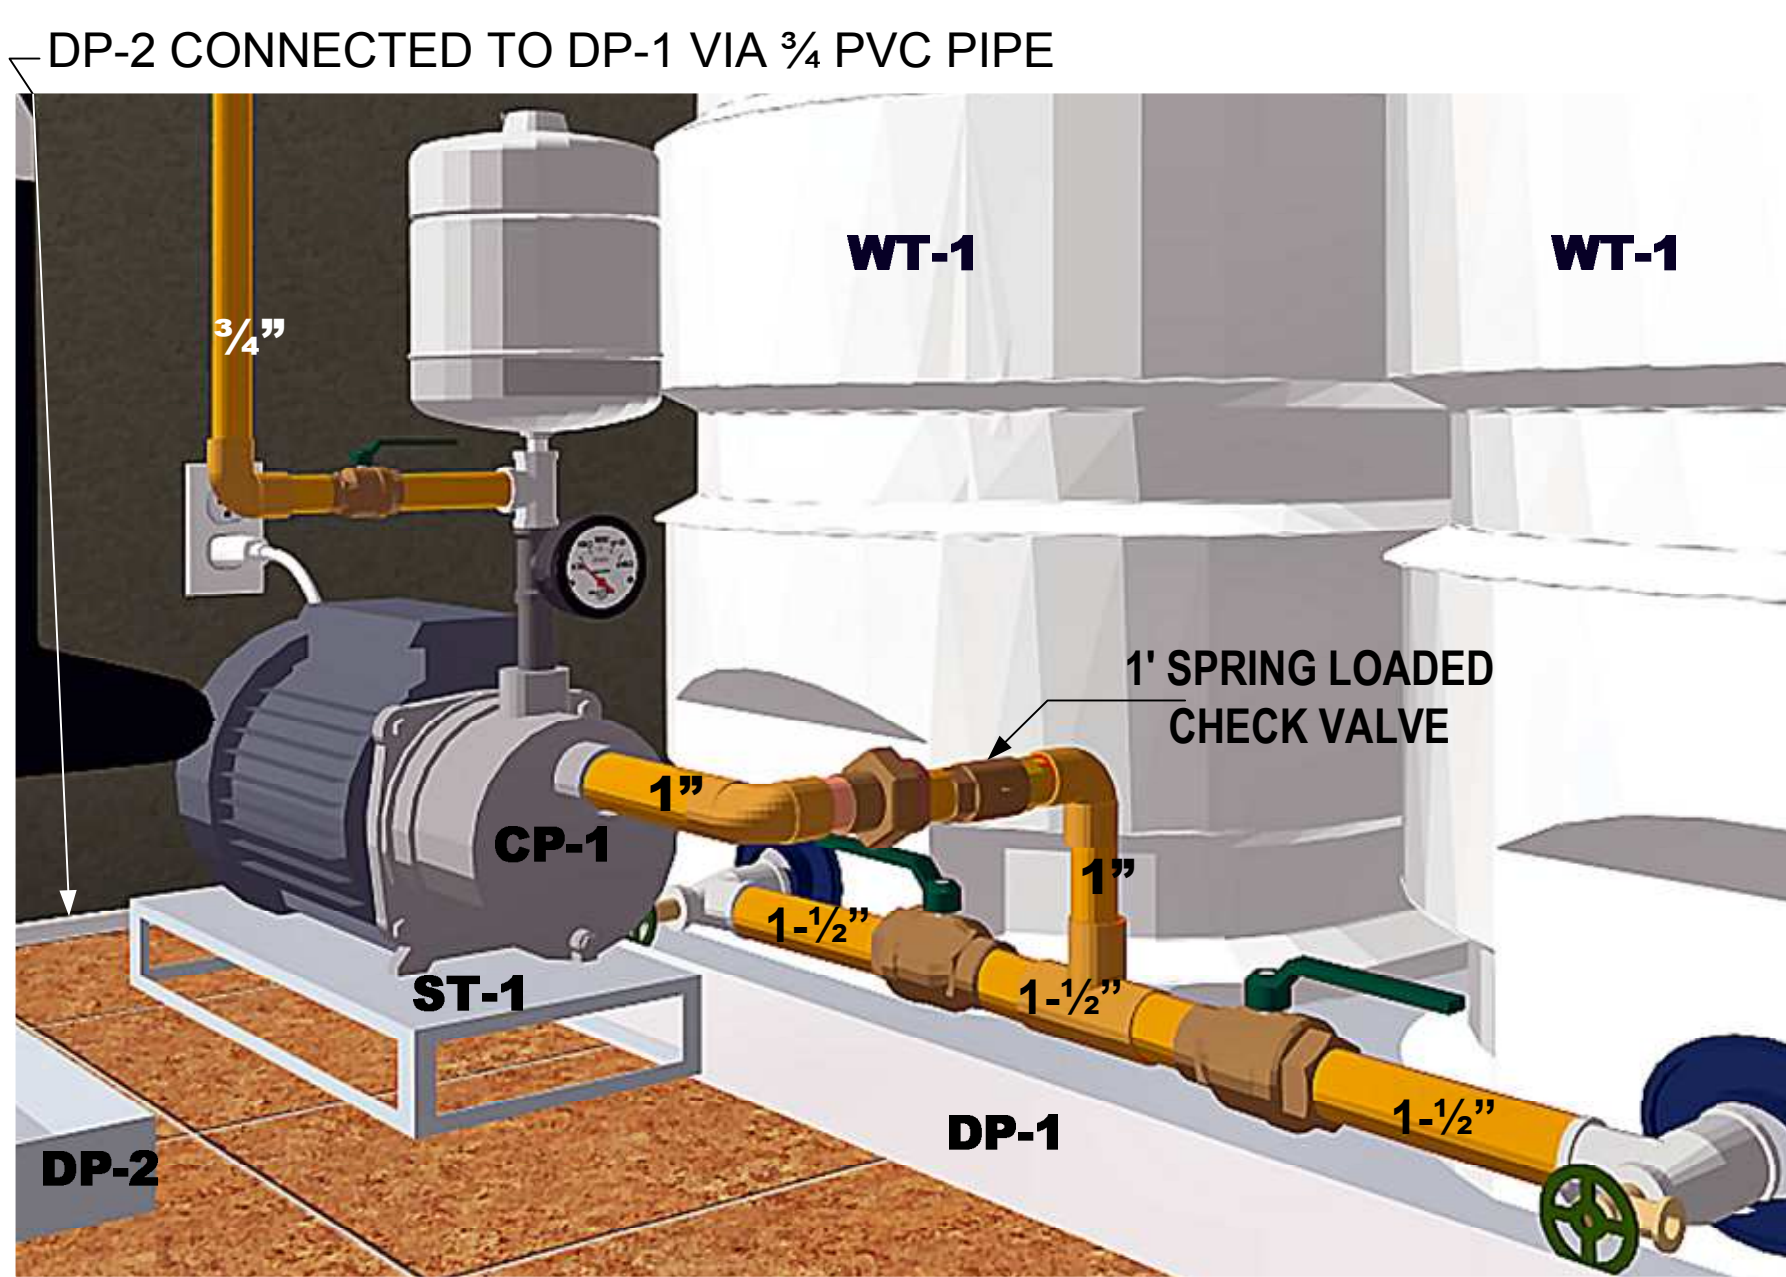


7 DOMESTIC WATER PUMP
Scale: n/a

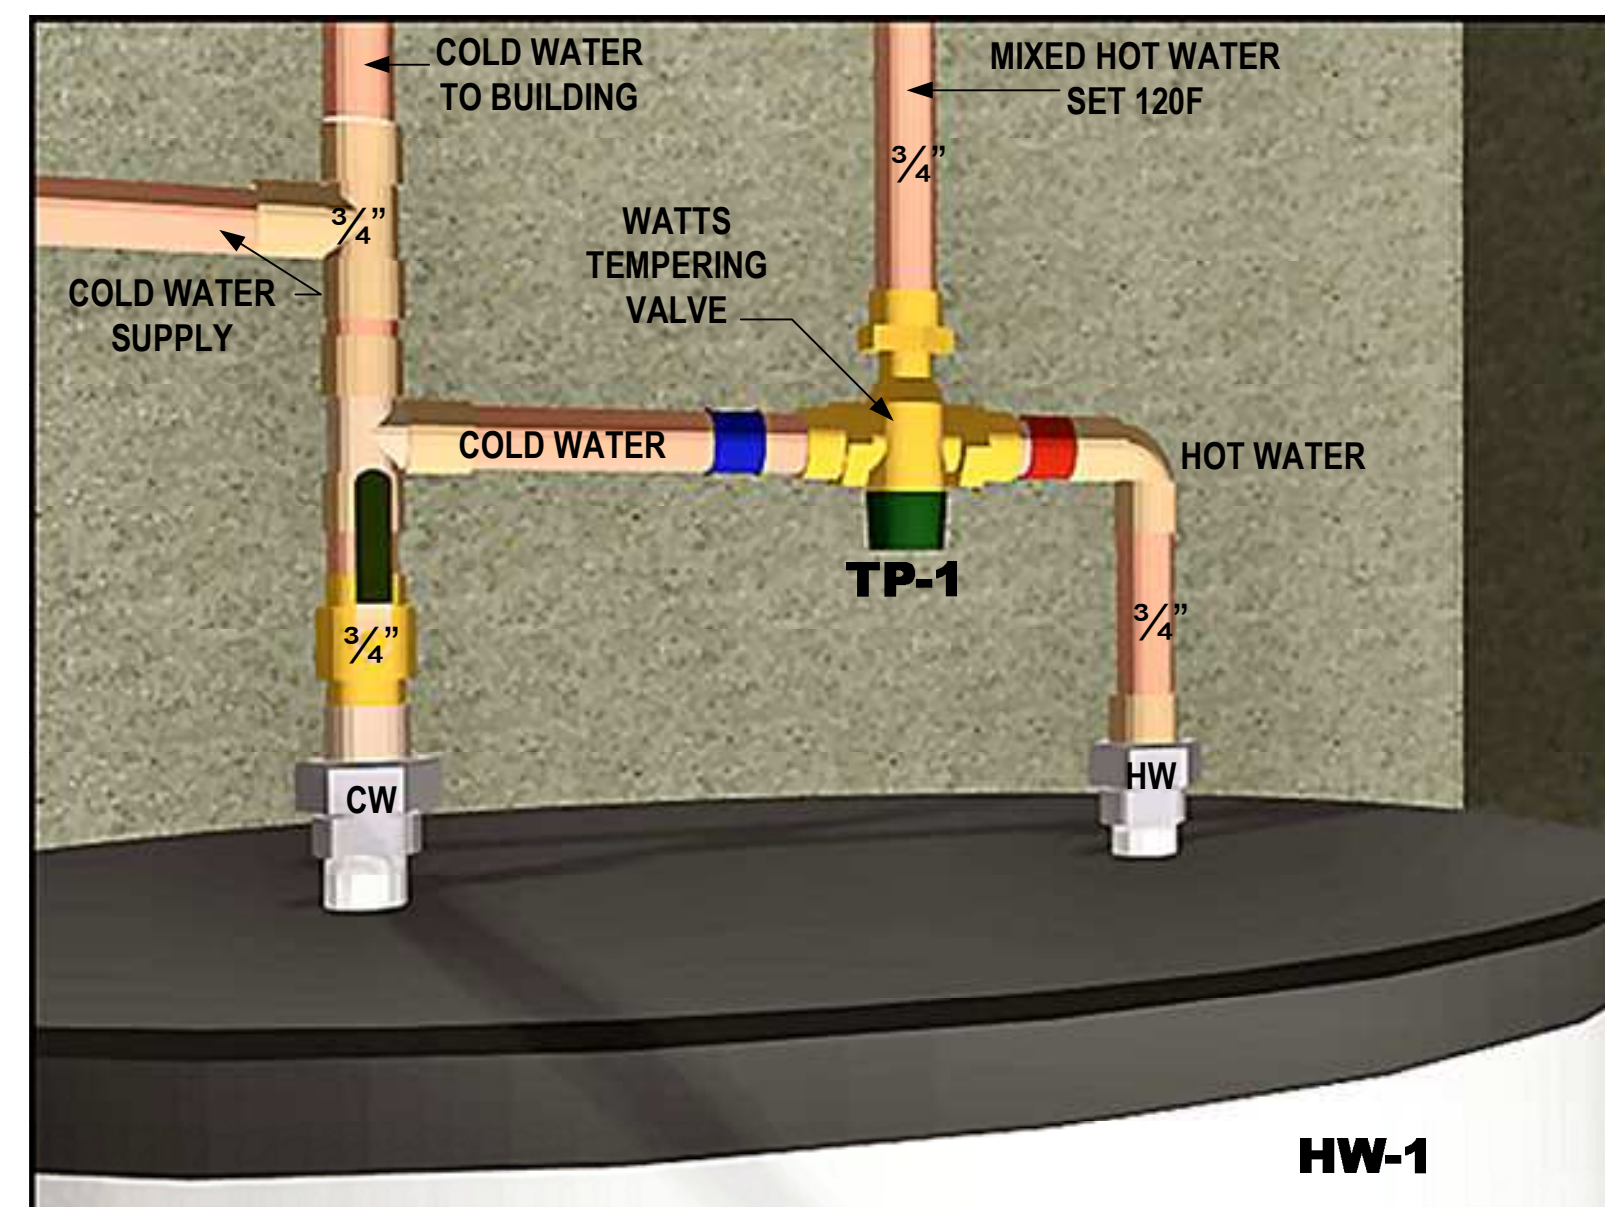

6 HW-1 MIXING VALVE
Scale: n/a

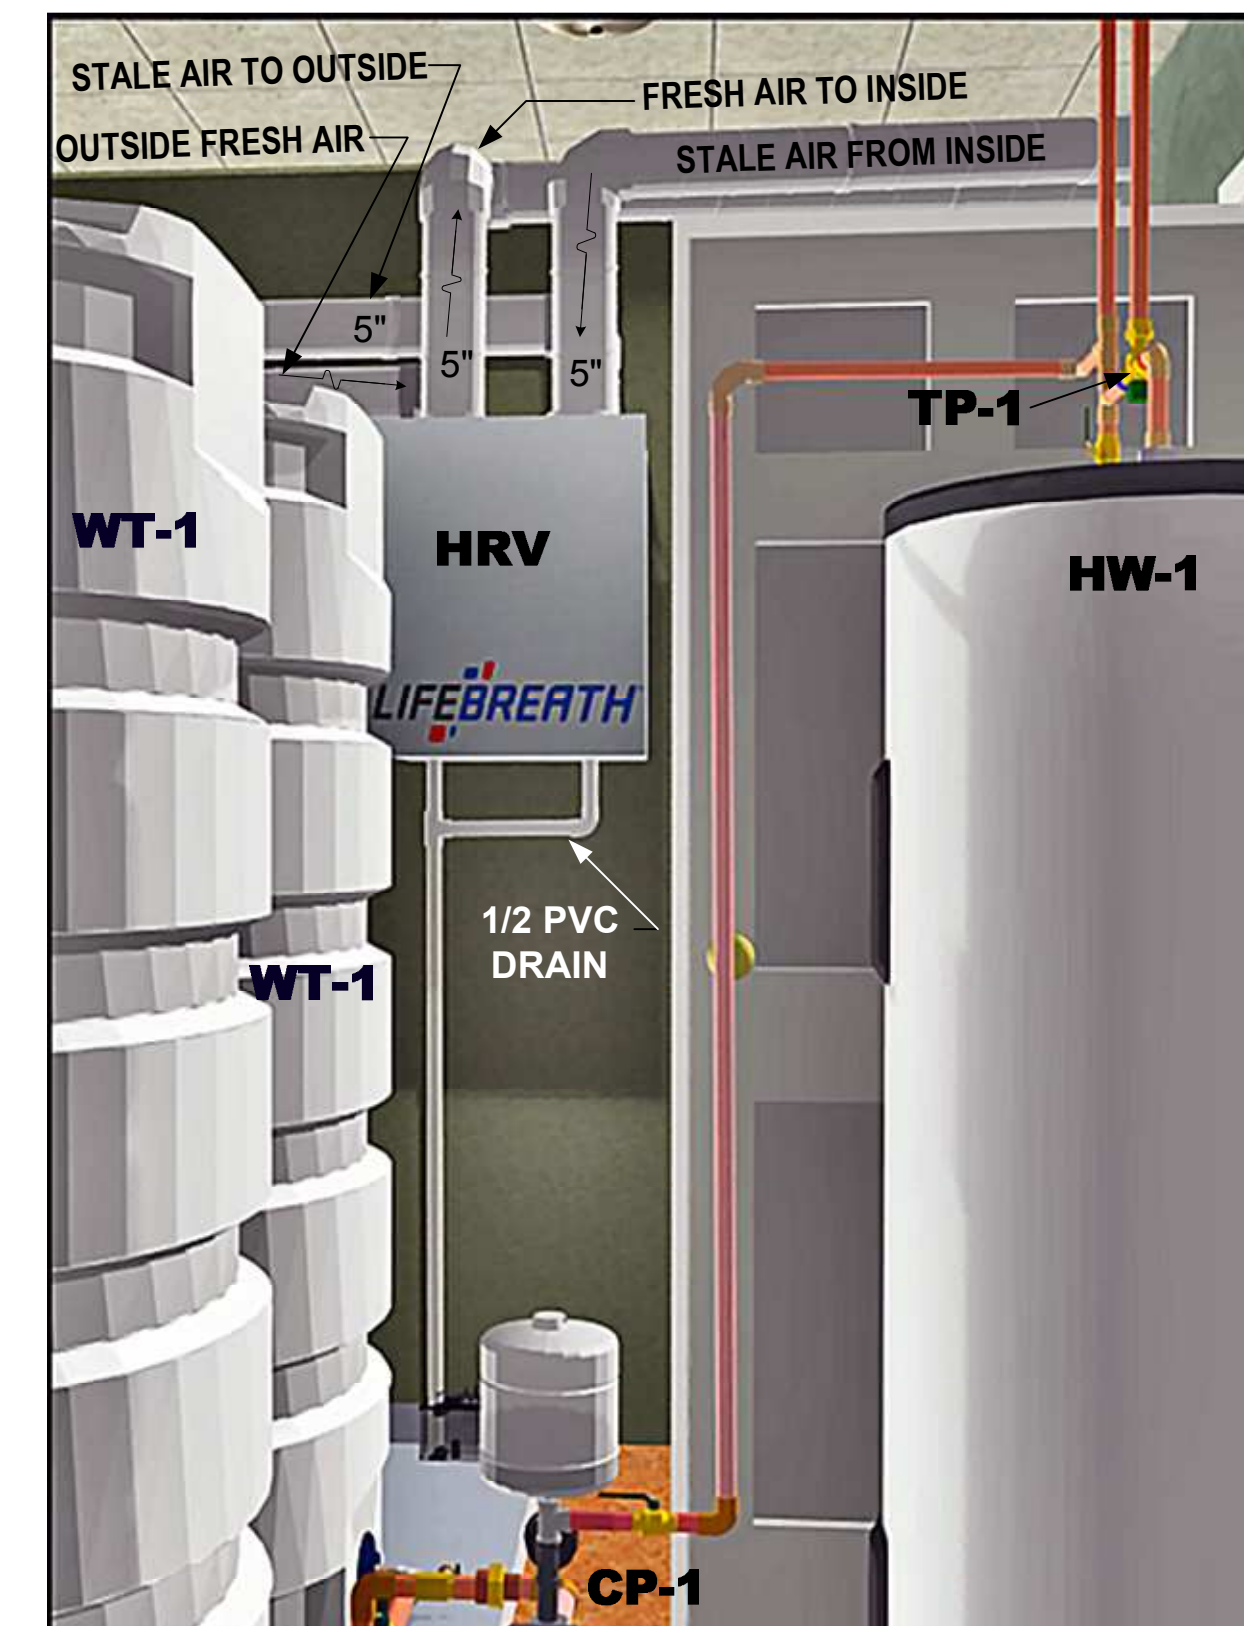

5 HEAT RECOVERY VENTILATOR (HRV)
Scale: n/a

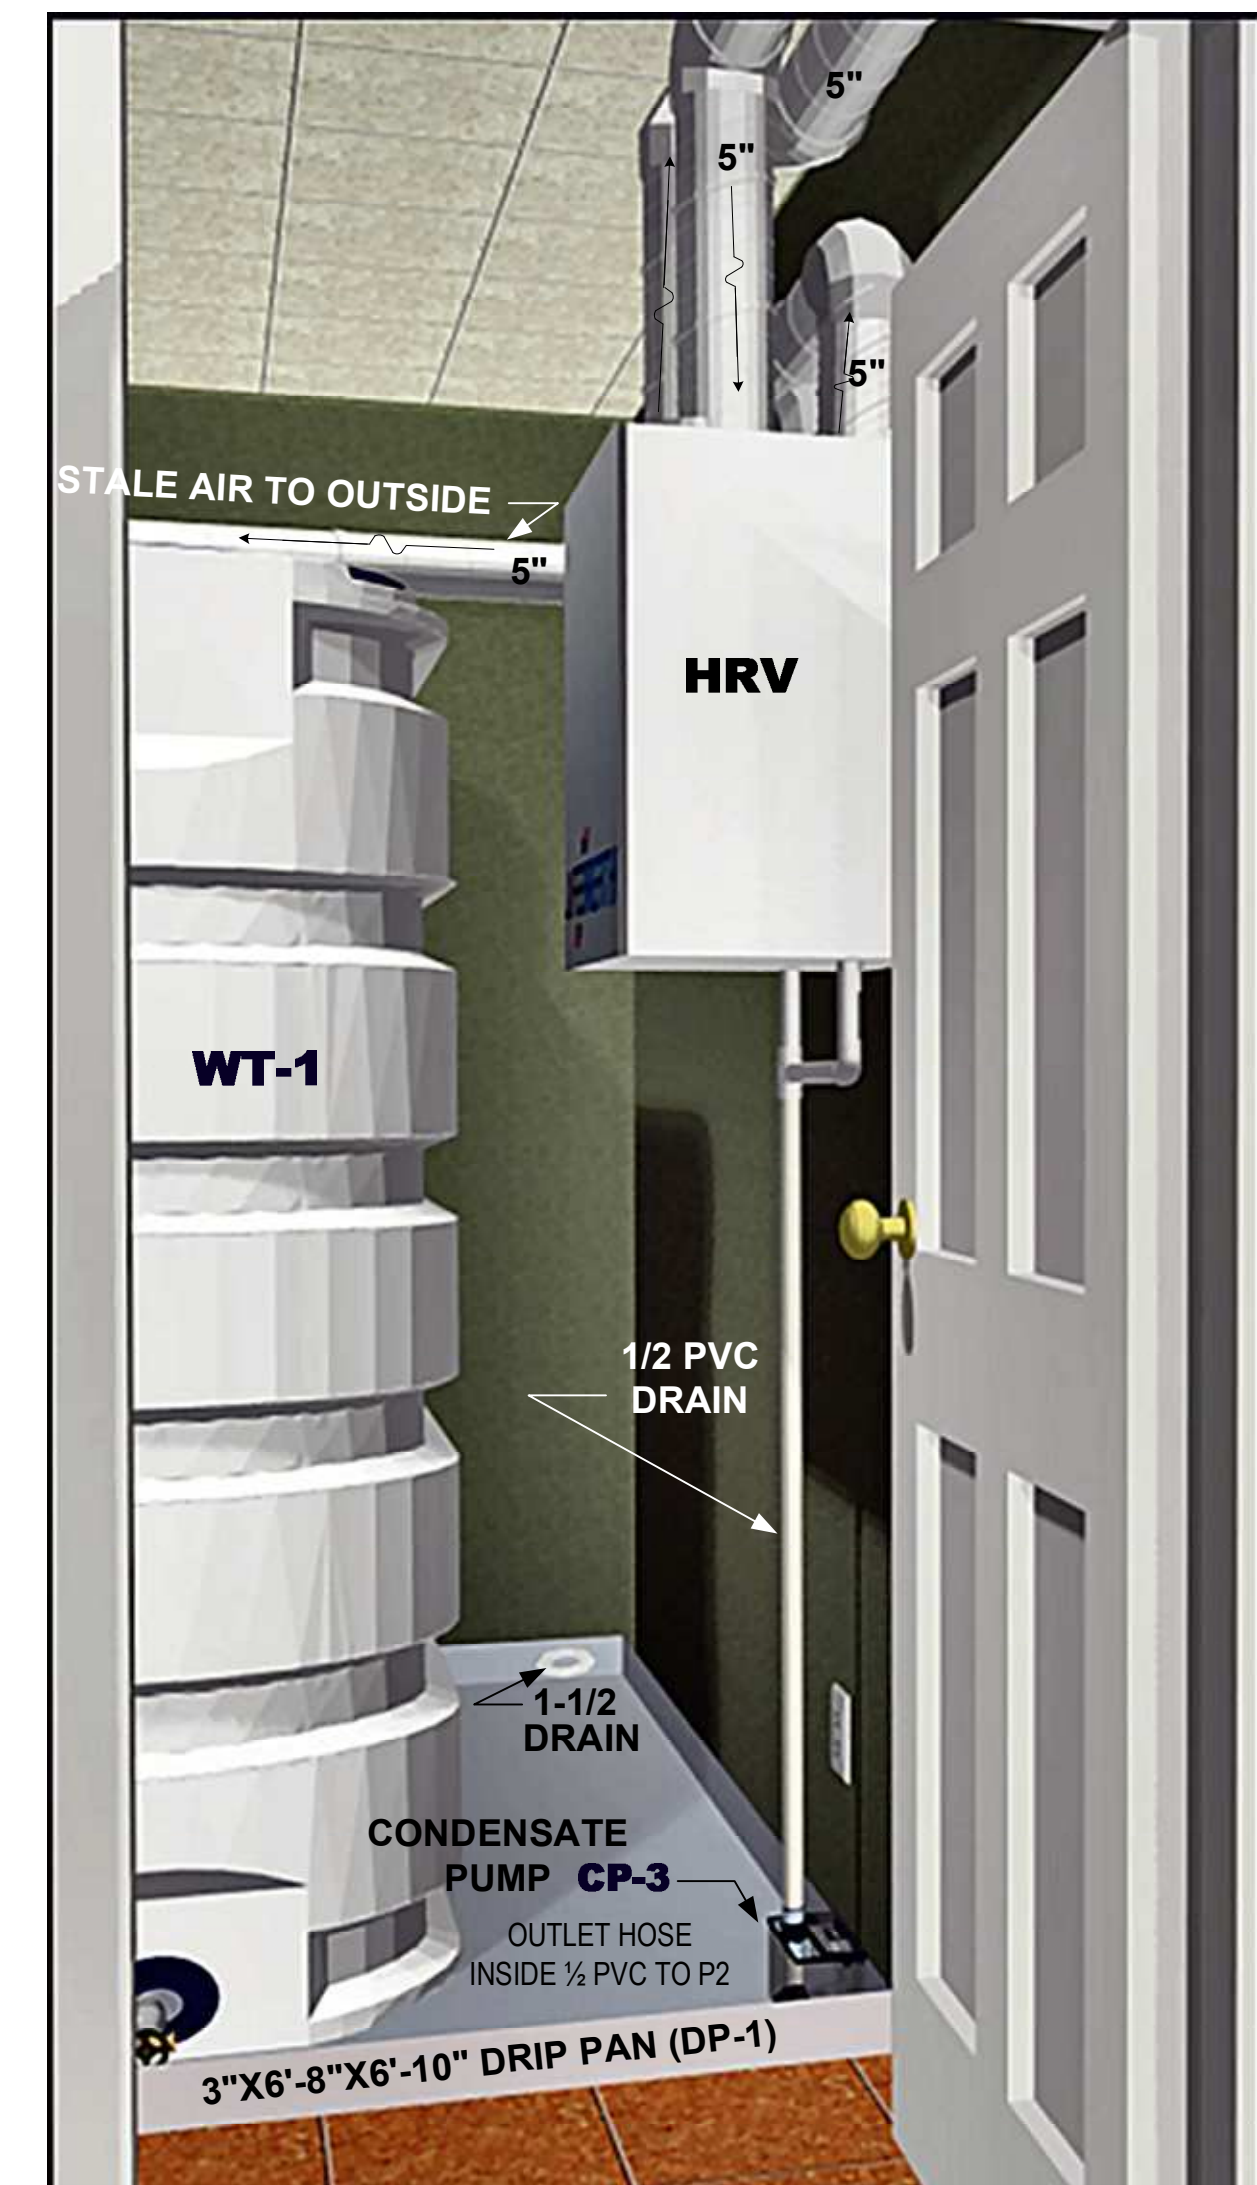

4 DRIP PAN & CONDENSATE PUMP
Scale: n/a

PROJECT: DEMONSTRATION & MONITORING PROJECT FOR AIR SOURCE HEAT PUMPS

SYSTEM: SOLAR HW HEATER, HRV & DOMESTIC WATER PUMP

REVISION: None

Revision: None

OceanAir HEATING & A/C CONTRACTING LLC

 
HEAT PUMP SYSTEMS


Scale: Per Detail
Design/drawn by jn
Date: 8/29/19
Job No.

Category: Sheet


M 4

NOTES:


- (1) CT= CURRENT TRANSFORMER →
- (2) eMonitor module installed in separate locked NEMA rated polycase recessed enclosure next to Load Center enclosure
- (3) eMonitor Gateway installed in locked secure cabinet in hallway see 

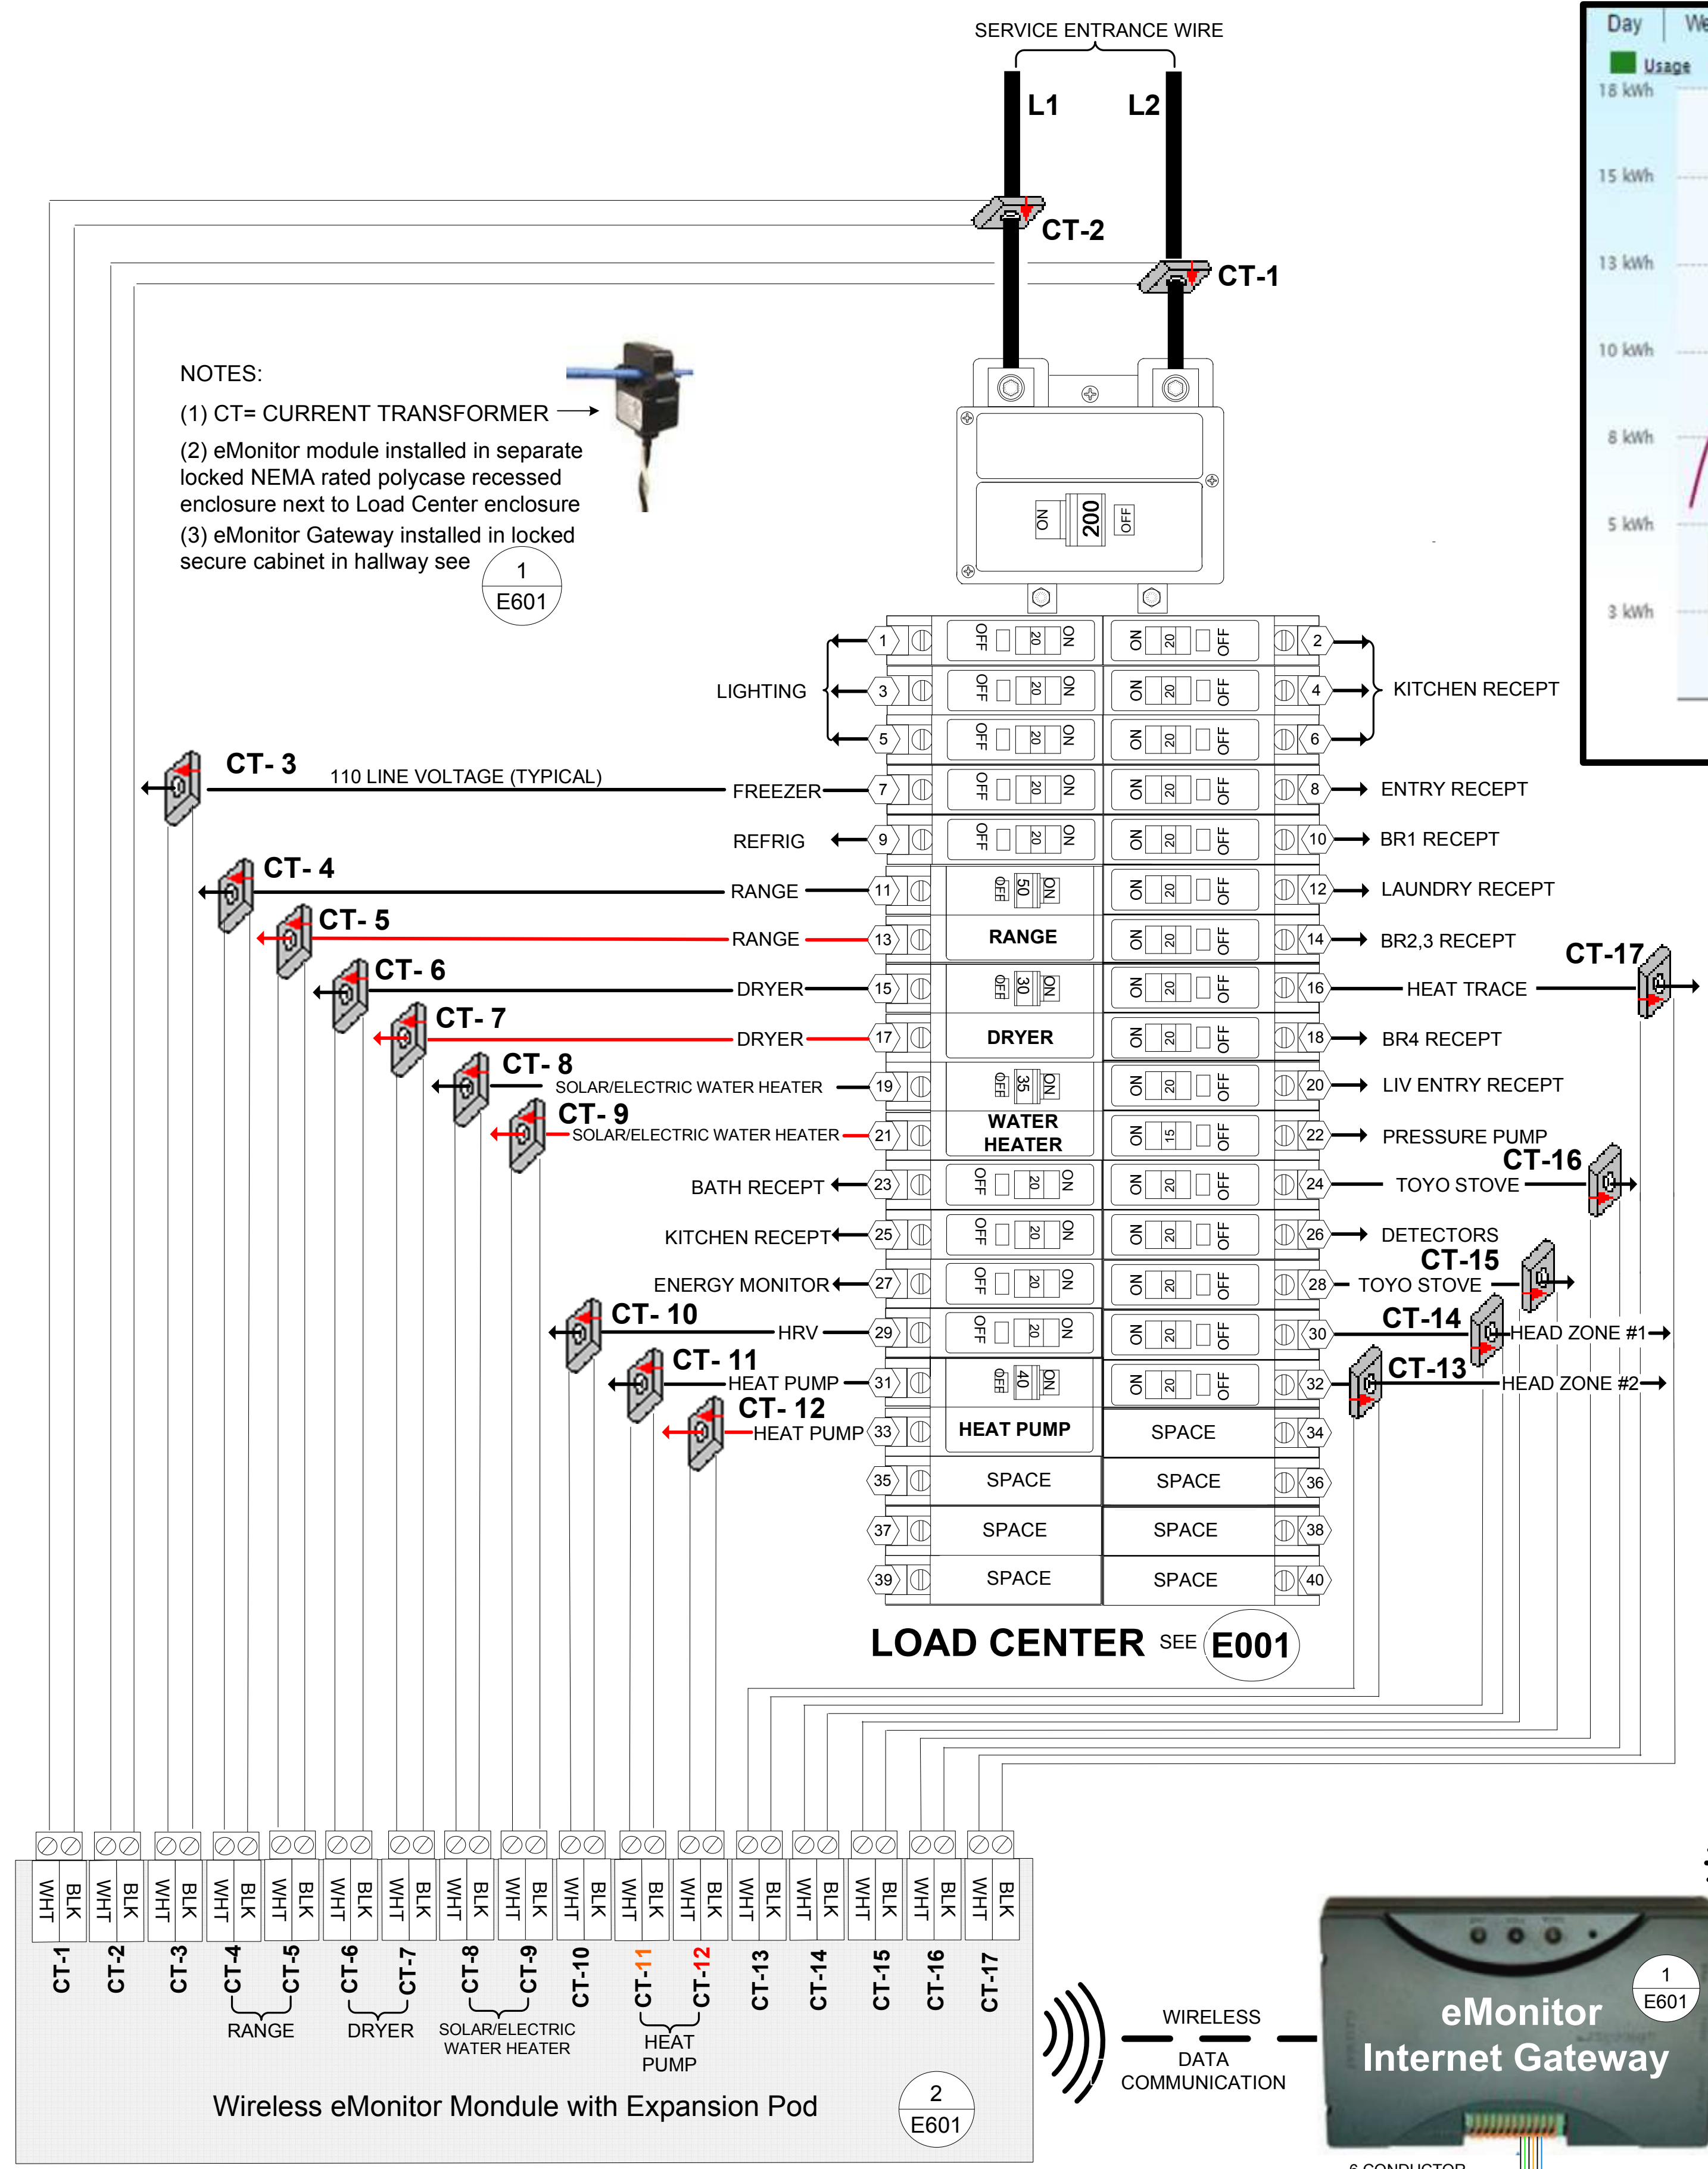

1 CT MODULE & WIRING DIAGRAM
17 DATA POINTS MONITORED

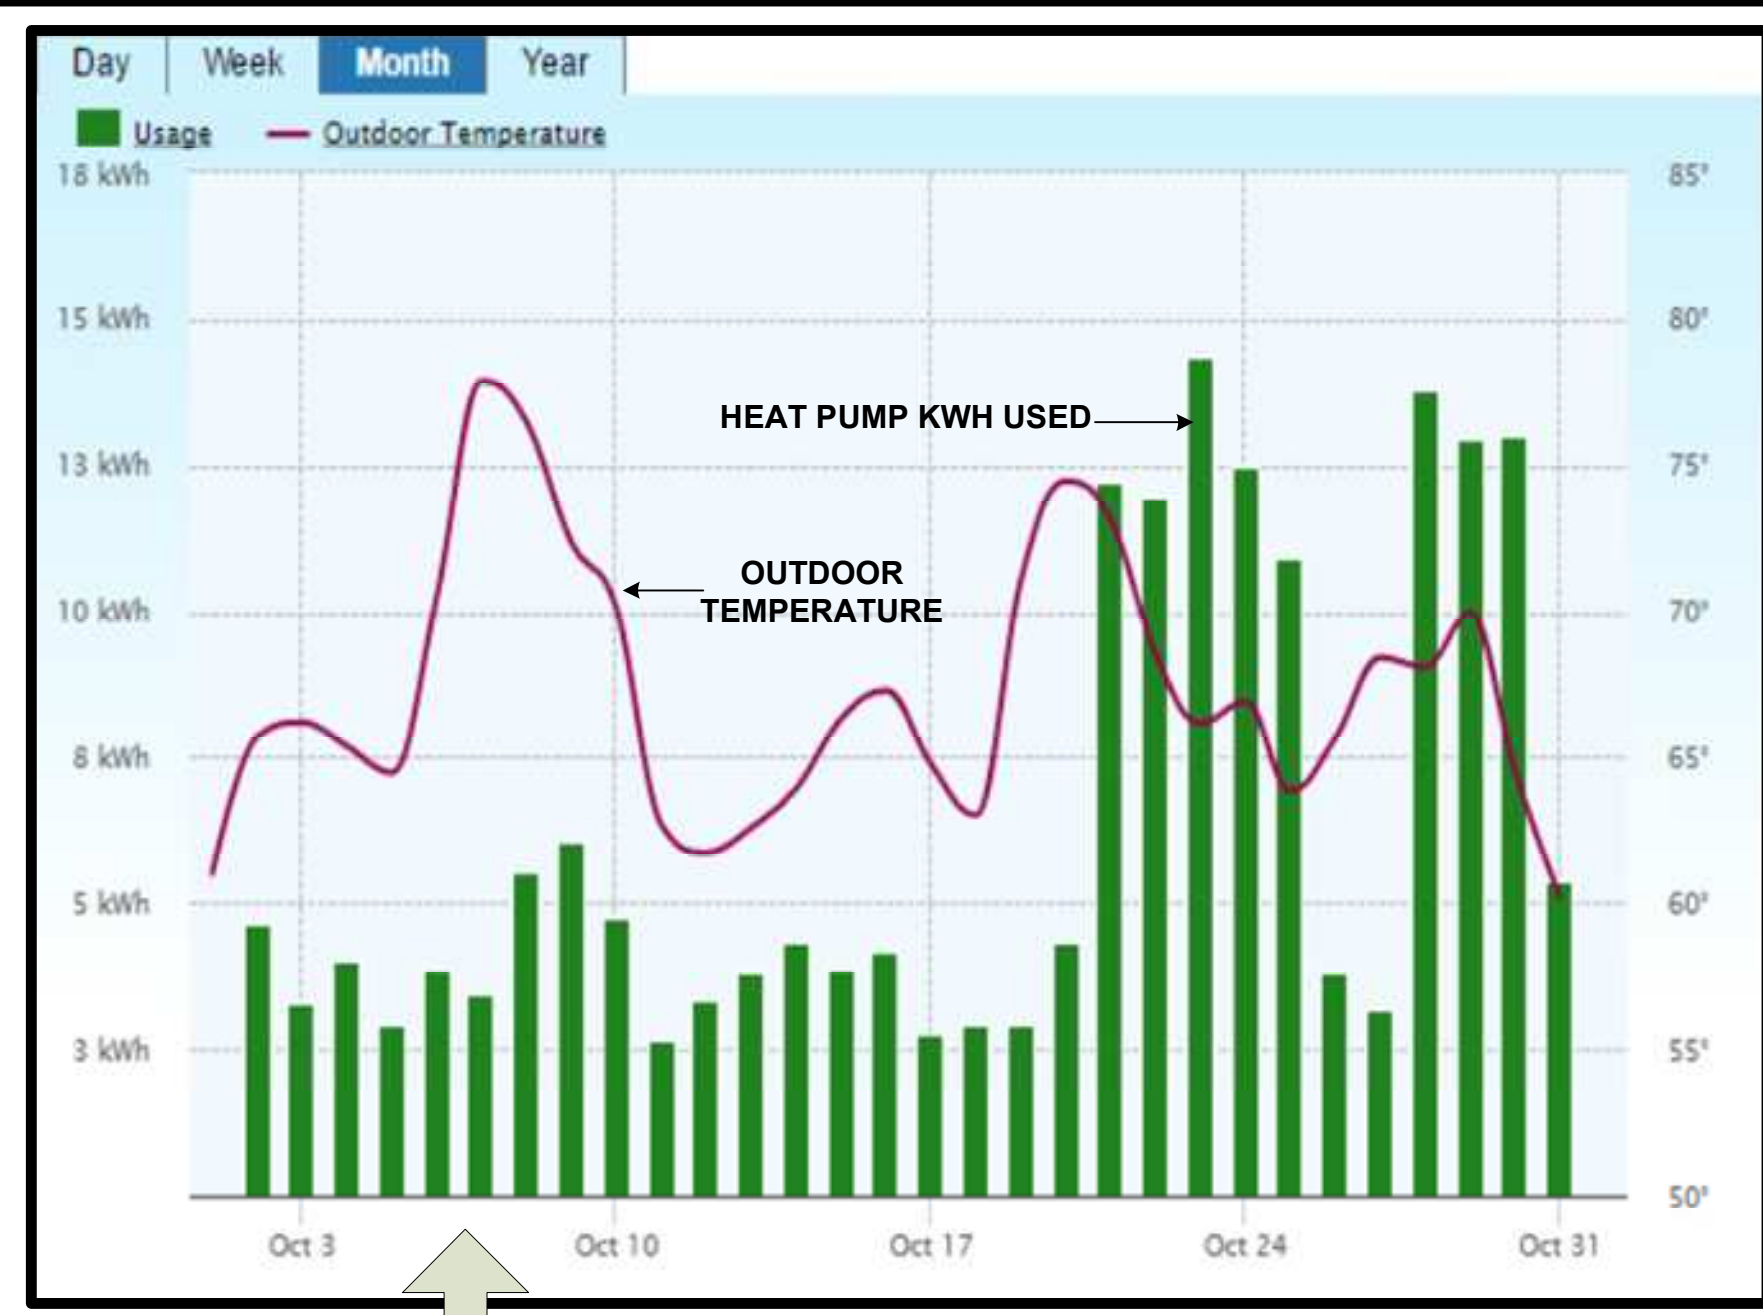

2 SITESAGE HEAT PUMP ANALYTICS
DATA COLLECTED FROM CT 11&12
EXAMPLE SCREENSHOT GRAPHIC

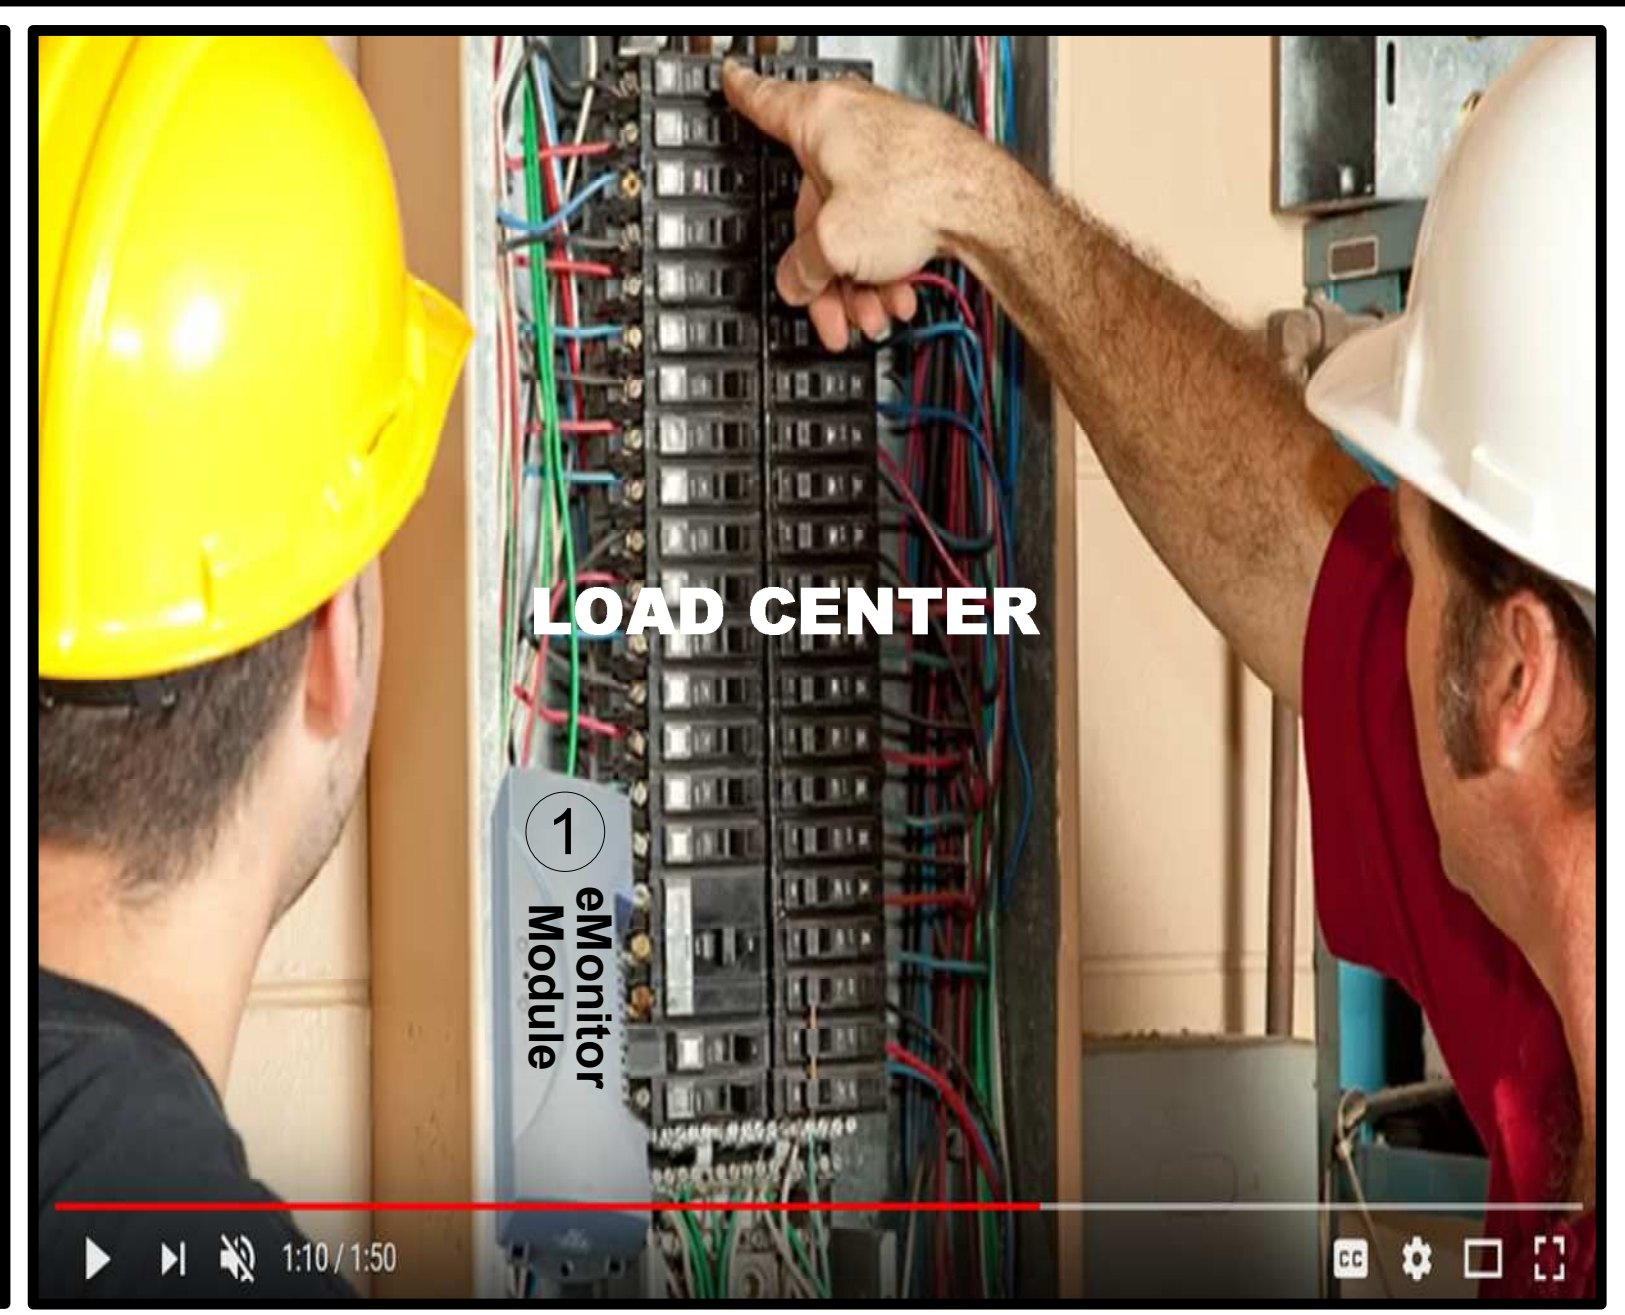



3 SITESAGE RESIDENTIAL INTRODUCTION
TYPE IN THE ABOVE CAPTION ON YouTube TO VIEW SOFTWARE & OVERVIEW IN HOW THE CT'S AND EMONITOR ARE INSTALLED



DESKTOP REMOTE ACCESS
MONITORING SOFTWARE & HARWARE BY:
<https://www.powerwisesystems.com/>



4 SITESAGE HEATING OIL ANALYTICS
SCREENSHOT DATA COLLECTED FROM PULSE FLOW OIL METER

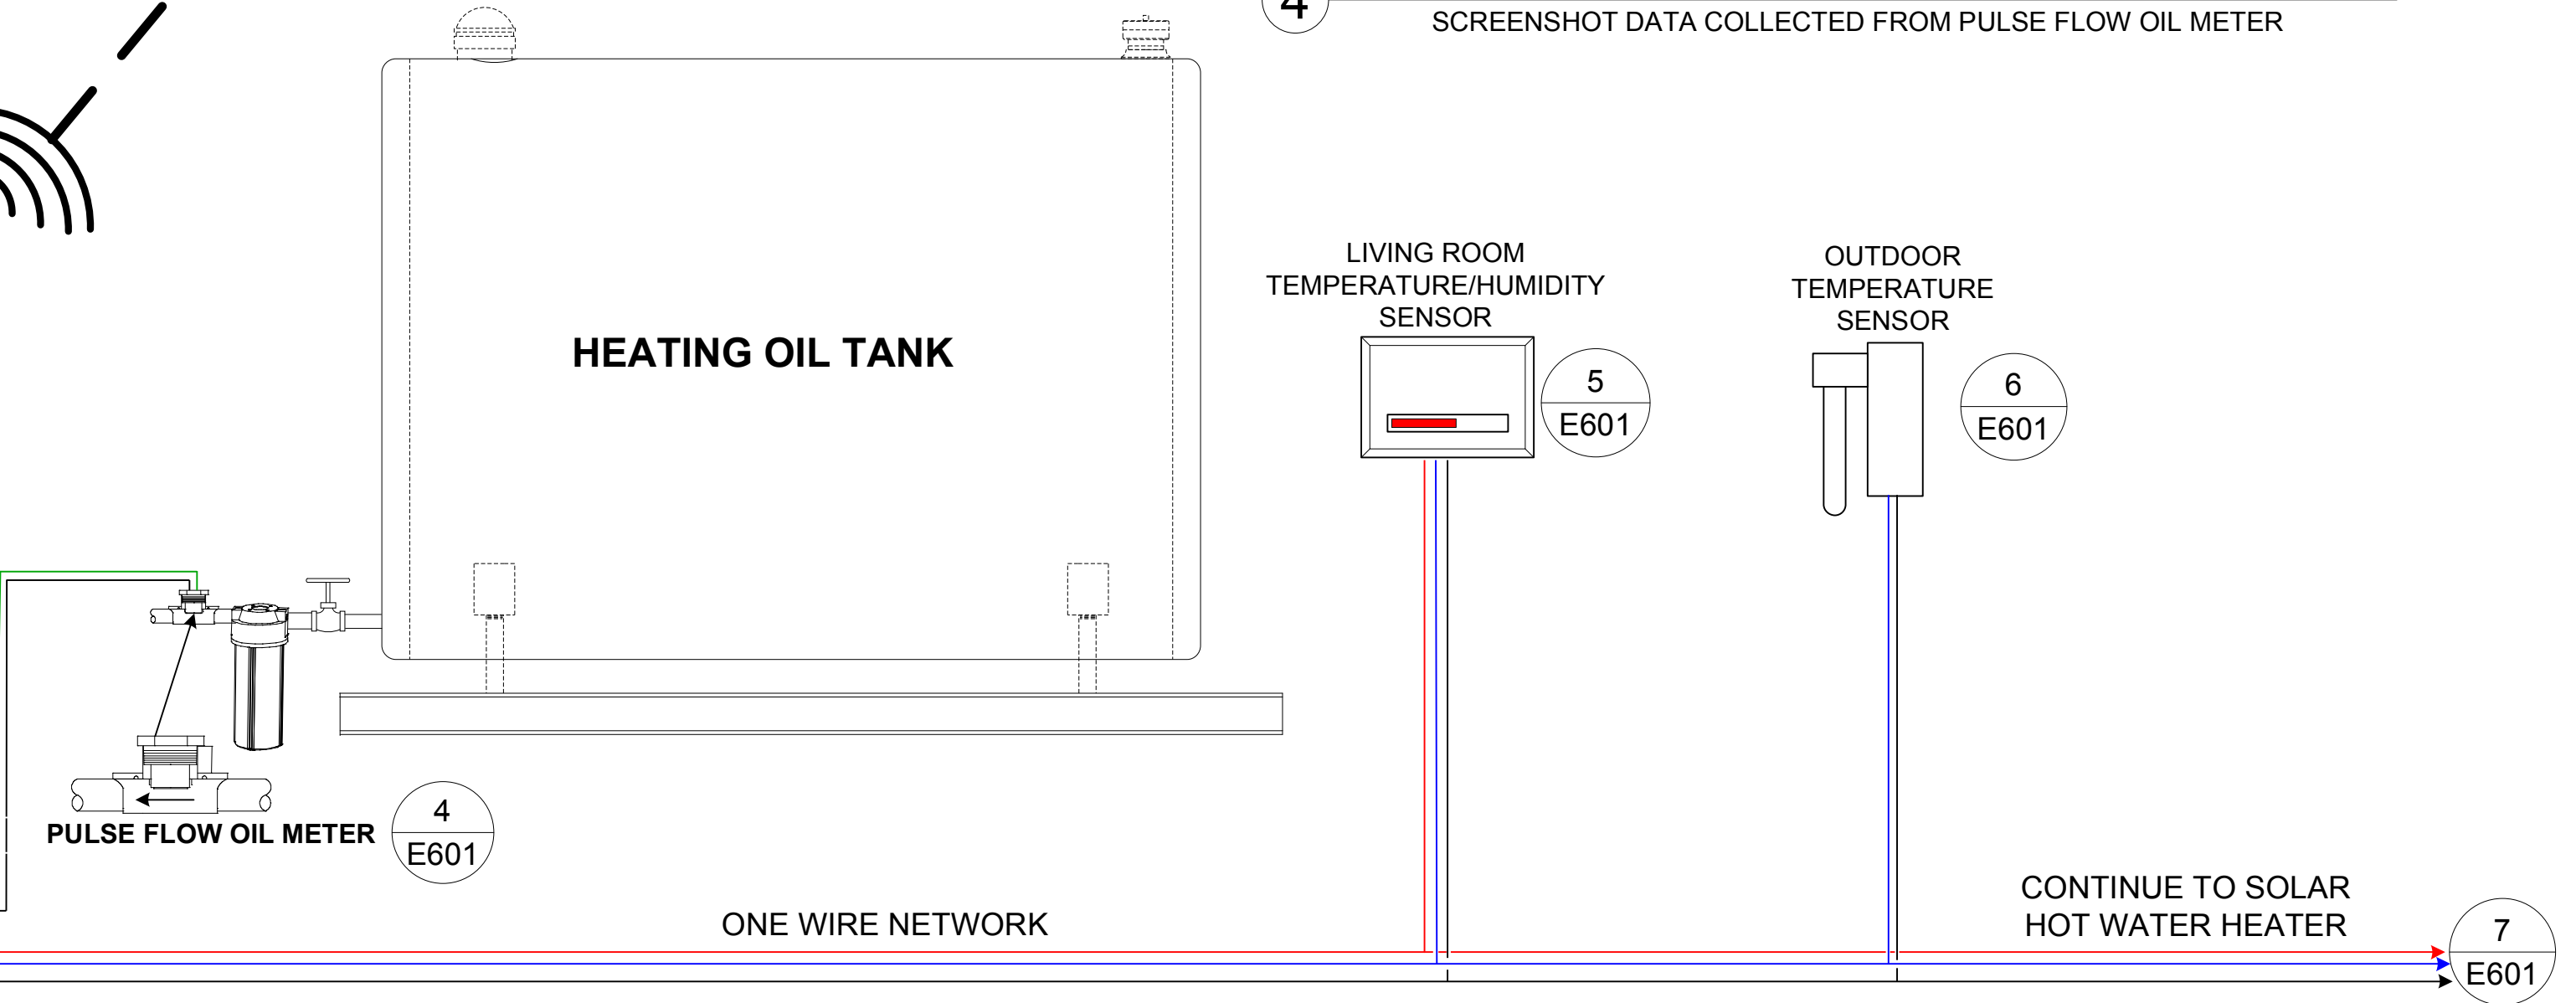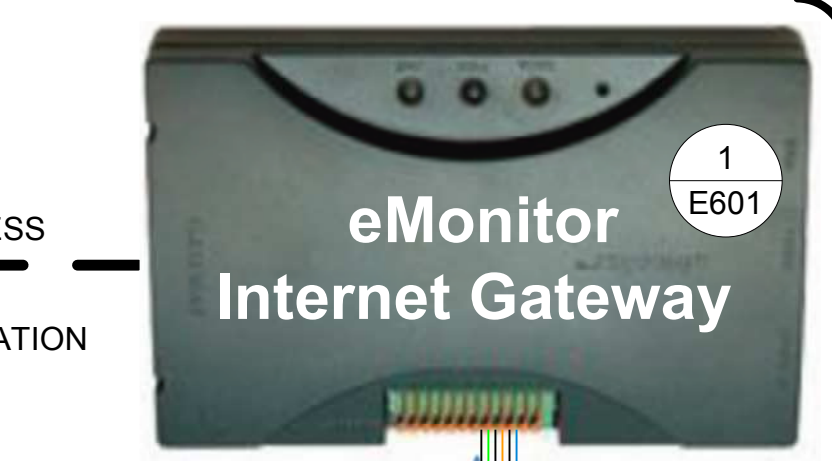

PROJECT **DEMONSTRATION & MONITORING PROJECT FOR AIR SOURCE HEAT PUMPS**

SYSTEM **CT /DEVICE MONITORING DIAGRAM & ARCHITECTURE**

REVISION: None

Actual installation Overview & Presentation

OceanAir HEATING & A/C CONTRACTING LLC
HEAT PUMP SYSTEMS

Scale:
Drawn by: jerry
Date: 3/19/19
Job No.

Category Sheet

E 501